

SITE LEGEND

- | | |
|---|---|
|  | TRANSFORMER WITH CONCRETE PAD |
|  | PARKING STALL COUNT TOTAL |
|  | DOCK HIGH TRUCK DOOR |
|  | 26' FIRE LANE |
|  | GRADE LEVEL TRUCK DOOR |
|  | PROPERTY LINE |
|  | ACCESSIBLE PATH OF TRAVEL 1:20 MAX. SLOPE, 2% MAX CROSS SLOPE |
|  | LANDSCAPE |

PROFESSIONAL STAMP:

AGENCY APPROVAL:

[illegible]

KEY PLAN:

Owner

**U-HAUL COMPANY OF
SAN FRANCISCO**

4150 POINT EDEN WAY

ENLARGED SITE PLAN

DRAWN BY: Author	CHECKED BY: Checker
DATE: 03/30/2020	PROJECT NO: U2301
SHEET NO:	

A-101

4/24/2020 5:39:37 PM BIM 360://U-Haul Hayward_rshahQ3EL2.rvt

 
① ENLARGED SITE PLAN
1" = 20'-0"

4/24/2020 5:39:37 PM

KEY PLAN:

DRAWN BY: RS	CHECKED BY: RFT
DATE: 03/30/2020	PROJECT NO: U2301
SHEET NO:	

A-104



PROFESSIONAL STAMP:

AGENCY APPROVAL:

KEY PLAN:

Owner

U-HAUL COMPANY OF SAN FRANCISCO

4150 POINT EDEN WAY

ROOF PLAN

DRAWN BY: Author	CHECKED BY: Checker
DATE: 03/30/2020	PROJECT NO: U2301
SHEET NO:	

A-105

KEY NOTES

- 1 ROOF STORM DRAIN
- 2 SKYLIGHT
- 3 WALL MOUNT SCONCES

SKYLIGHT


SKYLIGHT

SKYLIGHT SIZE: 48" X 96" - 32 SQFT

$$\frac{\text{BUILDING AREA SQFT} \times 2\%}{\text{SKYLIGHT SIZE}} = \frac{113730 \times 0.02}{32}$$

DESIRED :	71 SKYLIGHTS
PROVIDED:	72 SKYLIGHTS

 LEGEND



SKYLIGHT



ROOF DRAIN

THIS DOCUMENT, AND THE INFORMATION CONTAINED HEREIN, ARE THE SOLE PROPERTY OF ATI ARCHITECTS + ENGINEERS. ANY USE OR MODIFICATIONS OF THIS DOCUMENT, IN WHOLE OR IN PART, WITHOUT THE WRITTEN PERMISSION OF ATI ARCHITECTS + ENGINEERS, IS STRICTLY PROHIBITED.

4/24/2020 5:39:46 PM BIM 360://U-Haul Hayward/U-Haul Hayward_rshahQ3EL2.rvt

1 ROOF PLAN
1" = 20'-0"


1 ROOF PLAN
1" = 20'-0"

AGENCY APPROVAL:

KEY PLAN:


DRAWN BY: RS	CHECKED BY: RFT
DATE: 03/30/2020	PROJECT NO: U2301
SHEET NO:	

 A-301



4/24/2020 5:39:50 PM BIM 360://U-Haul Hayward/U-Haul Hayward_rshahQ3EL2.rvt

[illegible]

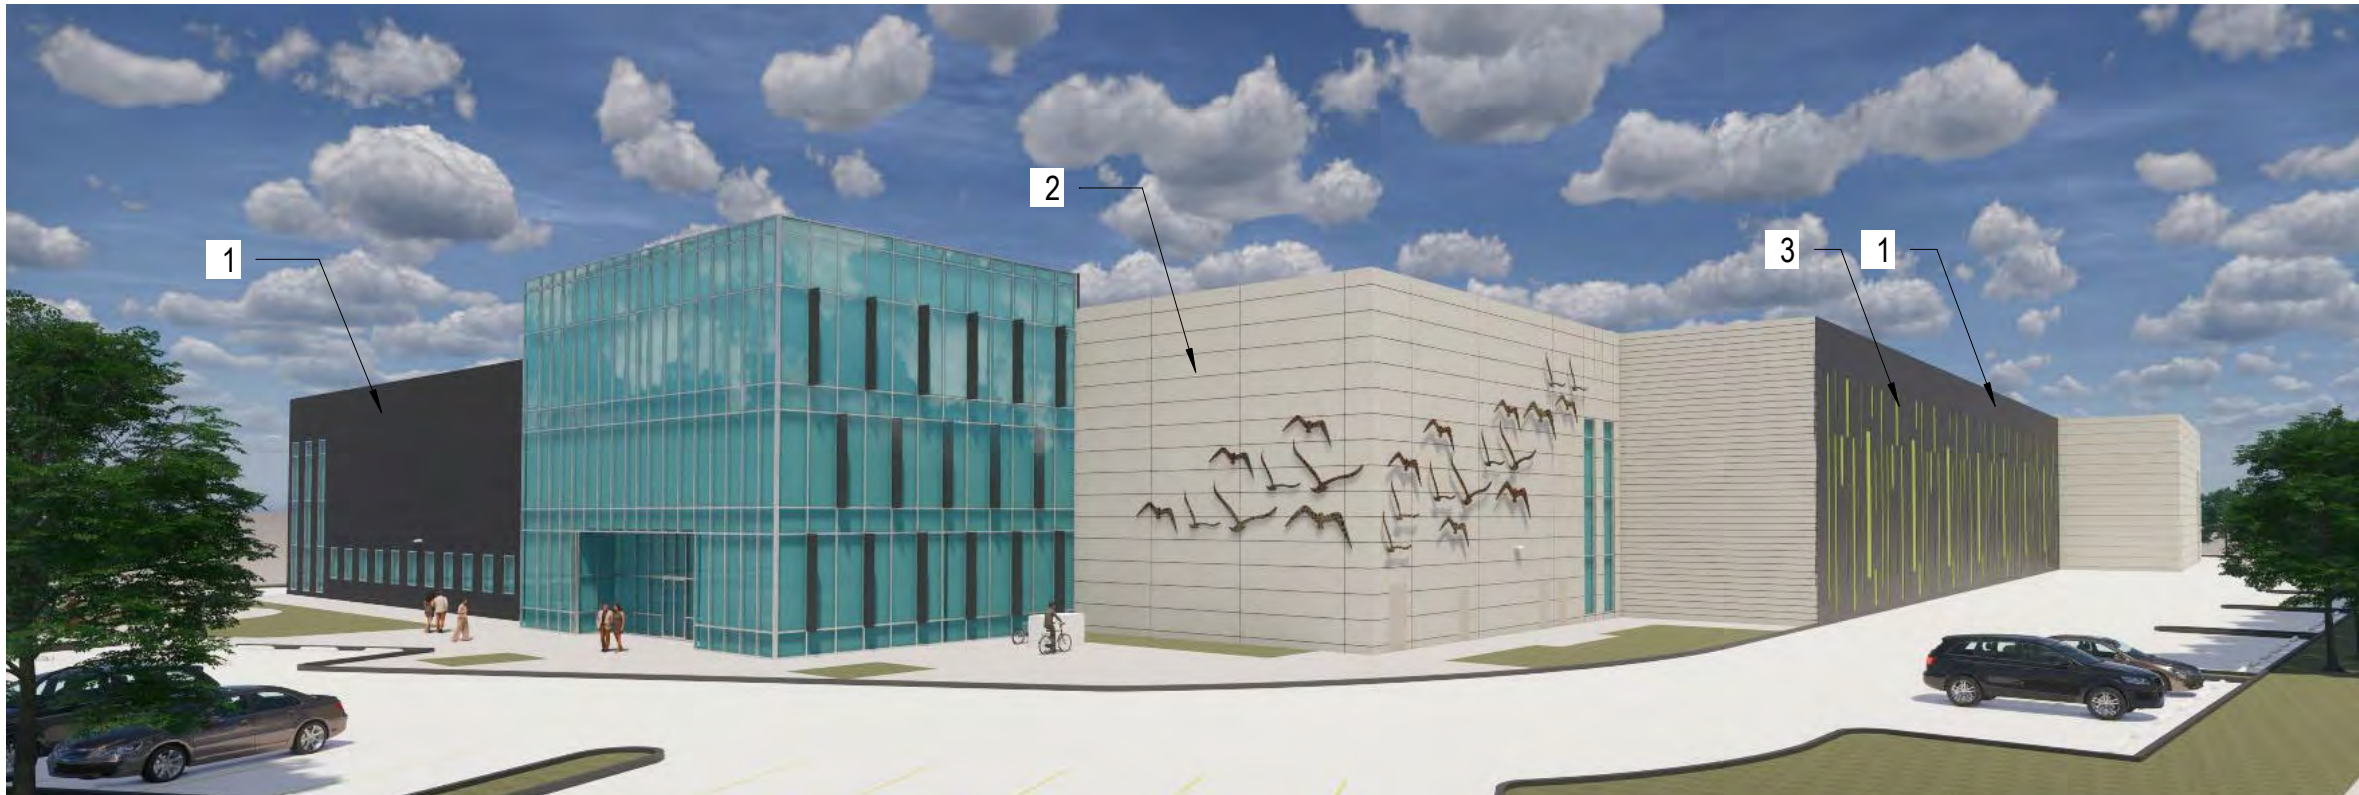

1	2	1
		
CENTRIA METAL PANEL 154 DARK BRONZE	STOREFRONT SYSTEM	CENTRIA METAL PANEL 154 DARK BRONZE
		
		



MATERIAL BOARD

Project number	U2301	A-502
Date	03/30/2020	
Drawn by	RS	
Checked by	RFT	
Scale 1 1/2" = 1'-0"		





KEY PLAN















Owner

4150 POINT EDEN WAY

DRAWN BY: Author	CHECKED BY: Checker
DATE: 03/30/2020	PROJECT NO: U2301
SHEET NO:	

                 A-601




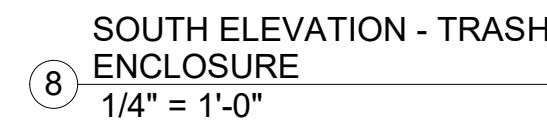




PHOTOMETRIC DATA USED AS INPUT FOR THESE CALCULATIONS
IS BASED ON ESTABLISHED IES PROCEDURES AND PUBLISHED
LAMP RATINGS. FIELD PERFORMANCE WILL DEPEND ON ACTUAL
LAMP, BALLAST, ELECTRICAL, AND SITE CHARACTERISTICS.

Calculations have been performed according to IES standards and good practice. Some differences between measured values and calculated results may occur due to variations in calculation methods, testing procedures, component performance, measurement techniques and field conditions such as voltage and temperature variations. Input data used to generate the attached calculations such as room dimensions, reflectances, furniture and architectural elements significantly affect the lighting calculations. If the real environment conditions do not match the input data, differences will occur between measured values and calculated values.

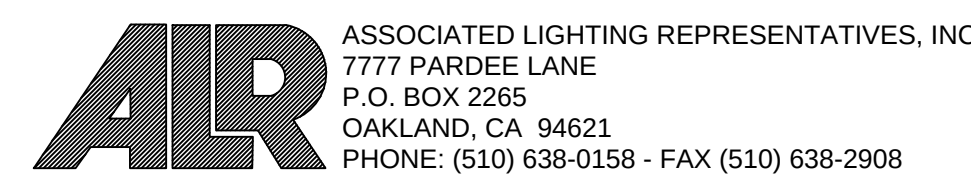



Lighting Analysts
 Illumination engineering software
www.agi32.com

 AGI32 VERSION 19.11
AGI (C) 2019 LIGHTING ANALYSTS, INC.
10268 W. CENTENNIAL ROAD, SUITE 202
LITTLETON, CO 80127

REV
X

Luminaire Schedule - LED											
Project U-HAUL - HAYWARD											
Symbol	Qty	Label	Arrangement	Lum. Watts	Lum. Lumens	LLF	LLD	LDD	UDF	Description	Filename
	7	AA	SINGLE	52.7703	8059	0.900	0.900	1.000	1.000	AR13-48N-MV-NW-4-XX-080	AR13-48N-MV-NW-4-XX-080.ies
	1	BB	SINGLE	52.8223	7941	0.900	0.900	1.000	1.000	AR13-48N-MV-NW-3-XX-080	AR13-48N-MV-NW-3-XX-080.ies
	10	W1	SINGLE	58.7	5738	0.900	0.900	1.000	1.000	ES1-24H-MV-NW-FT-XX-700	IES ES1-24H-MV-NW-FT-XX-700 05
	5	W2	SINGLE	58.6	5771	0.900	0.900	1.000	1.000	ES1-24H-MV-NW-W-XX-700	IES ES1-24H-MV-NW-W-XX-700 040

Calculation Summary								
Project: U-HAUL - HAYWARD								
Description	CalcType	Units	Grid 2	Avg	Max	Min	Avg/Min	Max/Min
AUTO PARKING AND PAVED DRIVES	Illuminance	Fc	0	0.68	2.62	0.17	4.00	15.41
EAST TRUCK DRIVE	Illuminance	Fc	0	0.60	2.69	0.11	5.45	24.45
TRUCK LOAD - UNLOAD AREA	Illuminance	Fc	0	0.84	2.54	0.20	4.20	12.70

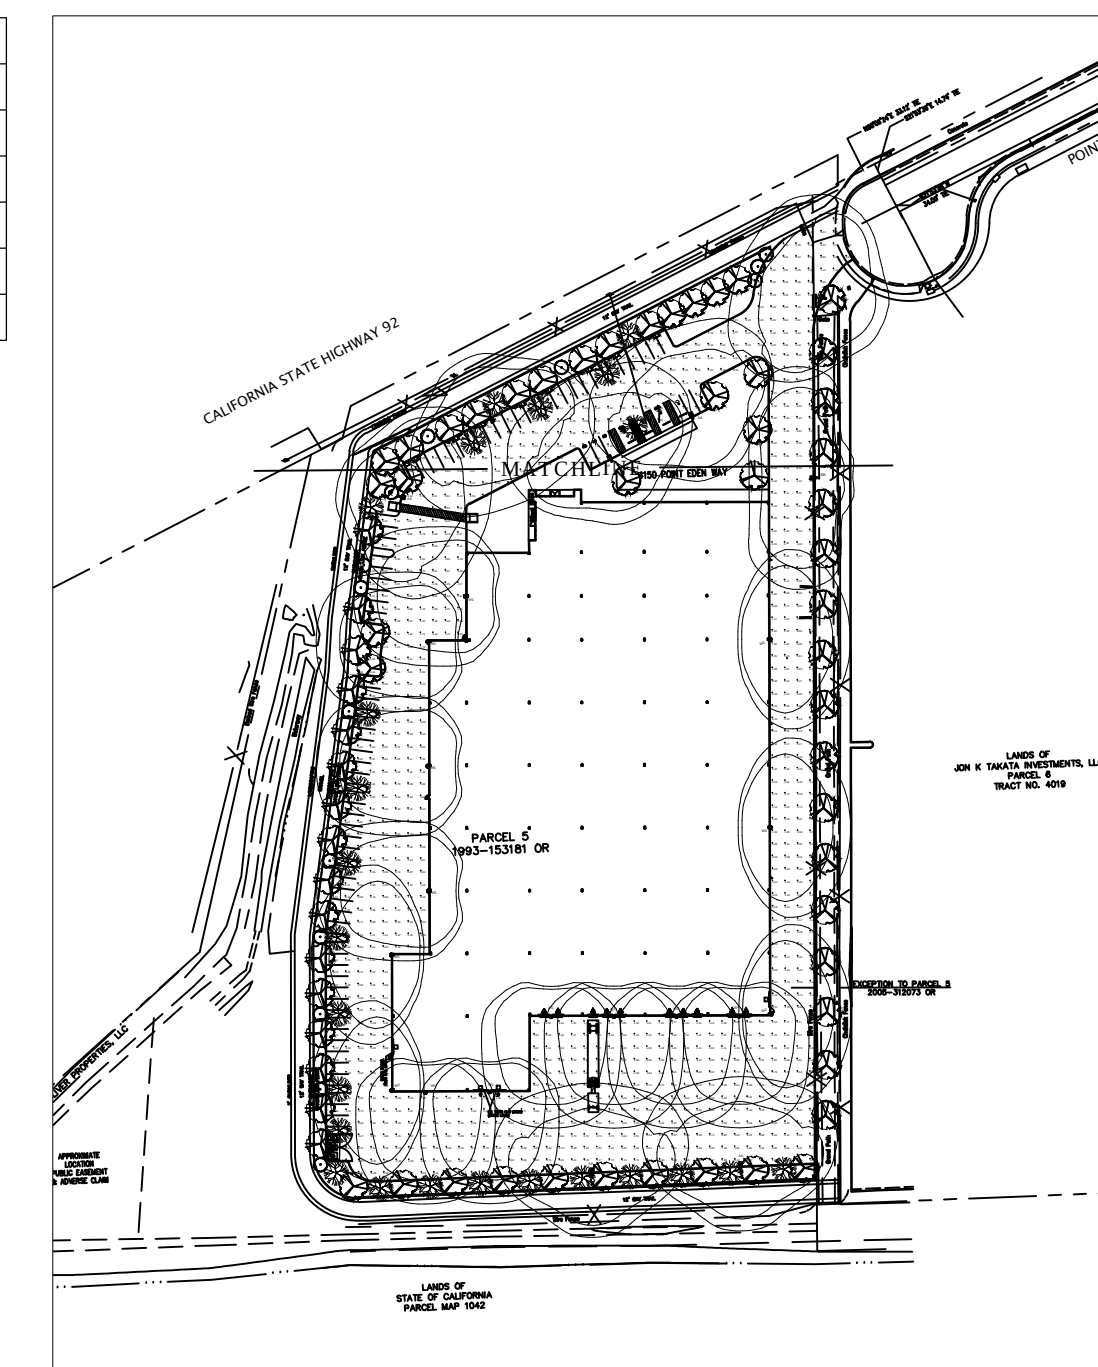


KEY PLAN:

PARKING ADAPTATION PLAN



DRAWN BY: RS	CHECKED BY: RFT
DATE: 04/24/2020	PROJECT NO: U2301
SHEET NO:	

PROJECT DATA			
ZONING:		IP-INDUSTRIAL PARK	
APN:		461-085-02-02	
NORTH SITE AREA			
GROSS:			6.83 AC
			297,762 SF
DETENTION:	@ 3.4%		8,743 SF
SLOPE:			0 SF
EASEMENTS:			
LANDSCAPE:	@ 16%		45,840 SF
NET:			5,58 AC
			243,179 SF
BUILDING FOOTPRINT:			113,730 SF
NORTH BUILDING USE:			
WAREHOUSE			110,321 SF
OFFICE			2,758 SF
COVERAGE:			
GROSS:			38%
NET:			47%
PARKING REQUIRED			
WAREHOUSE	1/500 SF		227.40 STALLS
TOTAL			227 STALLS
PARKING PROVIDED:			
AUTO:			228 STALLS
REQ. ACCESSIBLE			2 STALLS
REQ. EV			2 STALLS
BIKE STALLS			2 STALLS
BIKE LOCKER			2 STALLS
BUILDING TRUCK DOCKS:			
9X9 DOCK- HIGH OH DOORS			0
12X10 GRADE LEVEL OH DOORS			0

THIS DOCUMENT AND THE INFORMATION CONTAINED HEREIN ARE THE SOLE PROPERTY OF ATI ARCHITECTS + ENGINEERS. ANY USE OR MODIFICATIONS OF THIS DOCUMENT IN WHOLE OR IN PART WITHOUT THE WRITTEN PERMISSION OF ATI ARCHITECTS + ENGINEERS IS STRICTLY PROHIBITED.

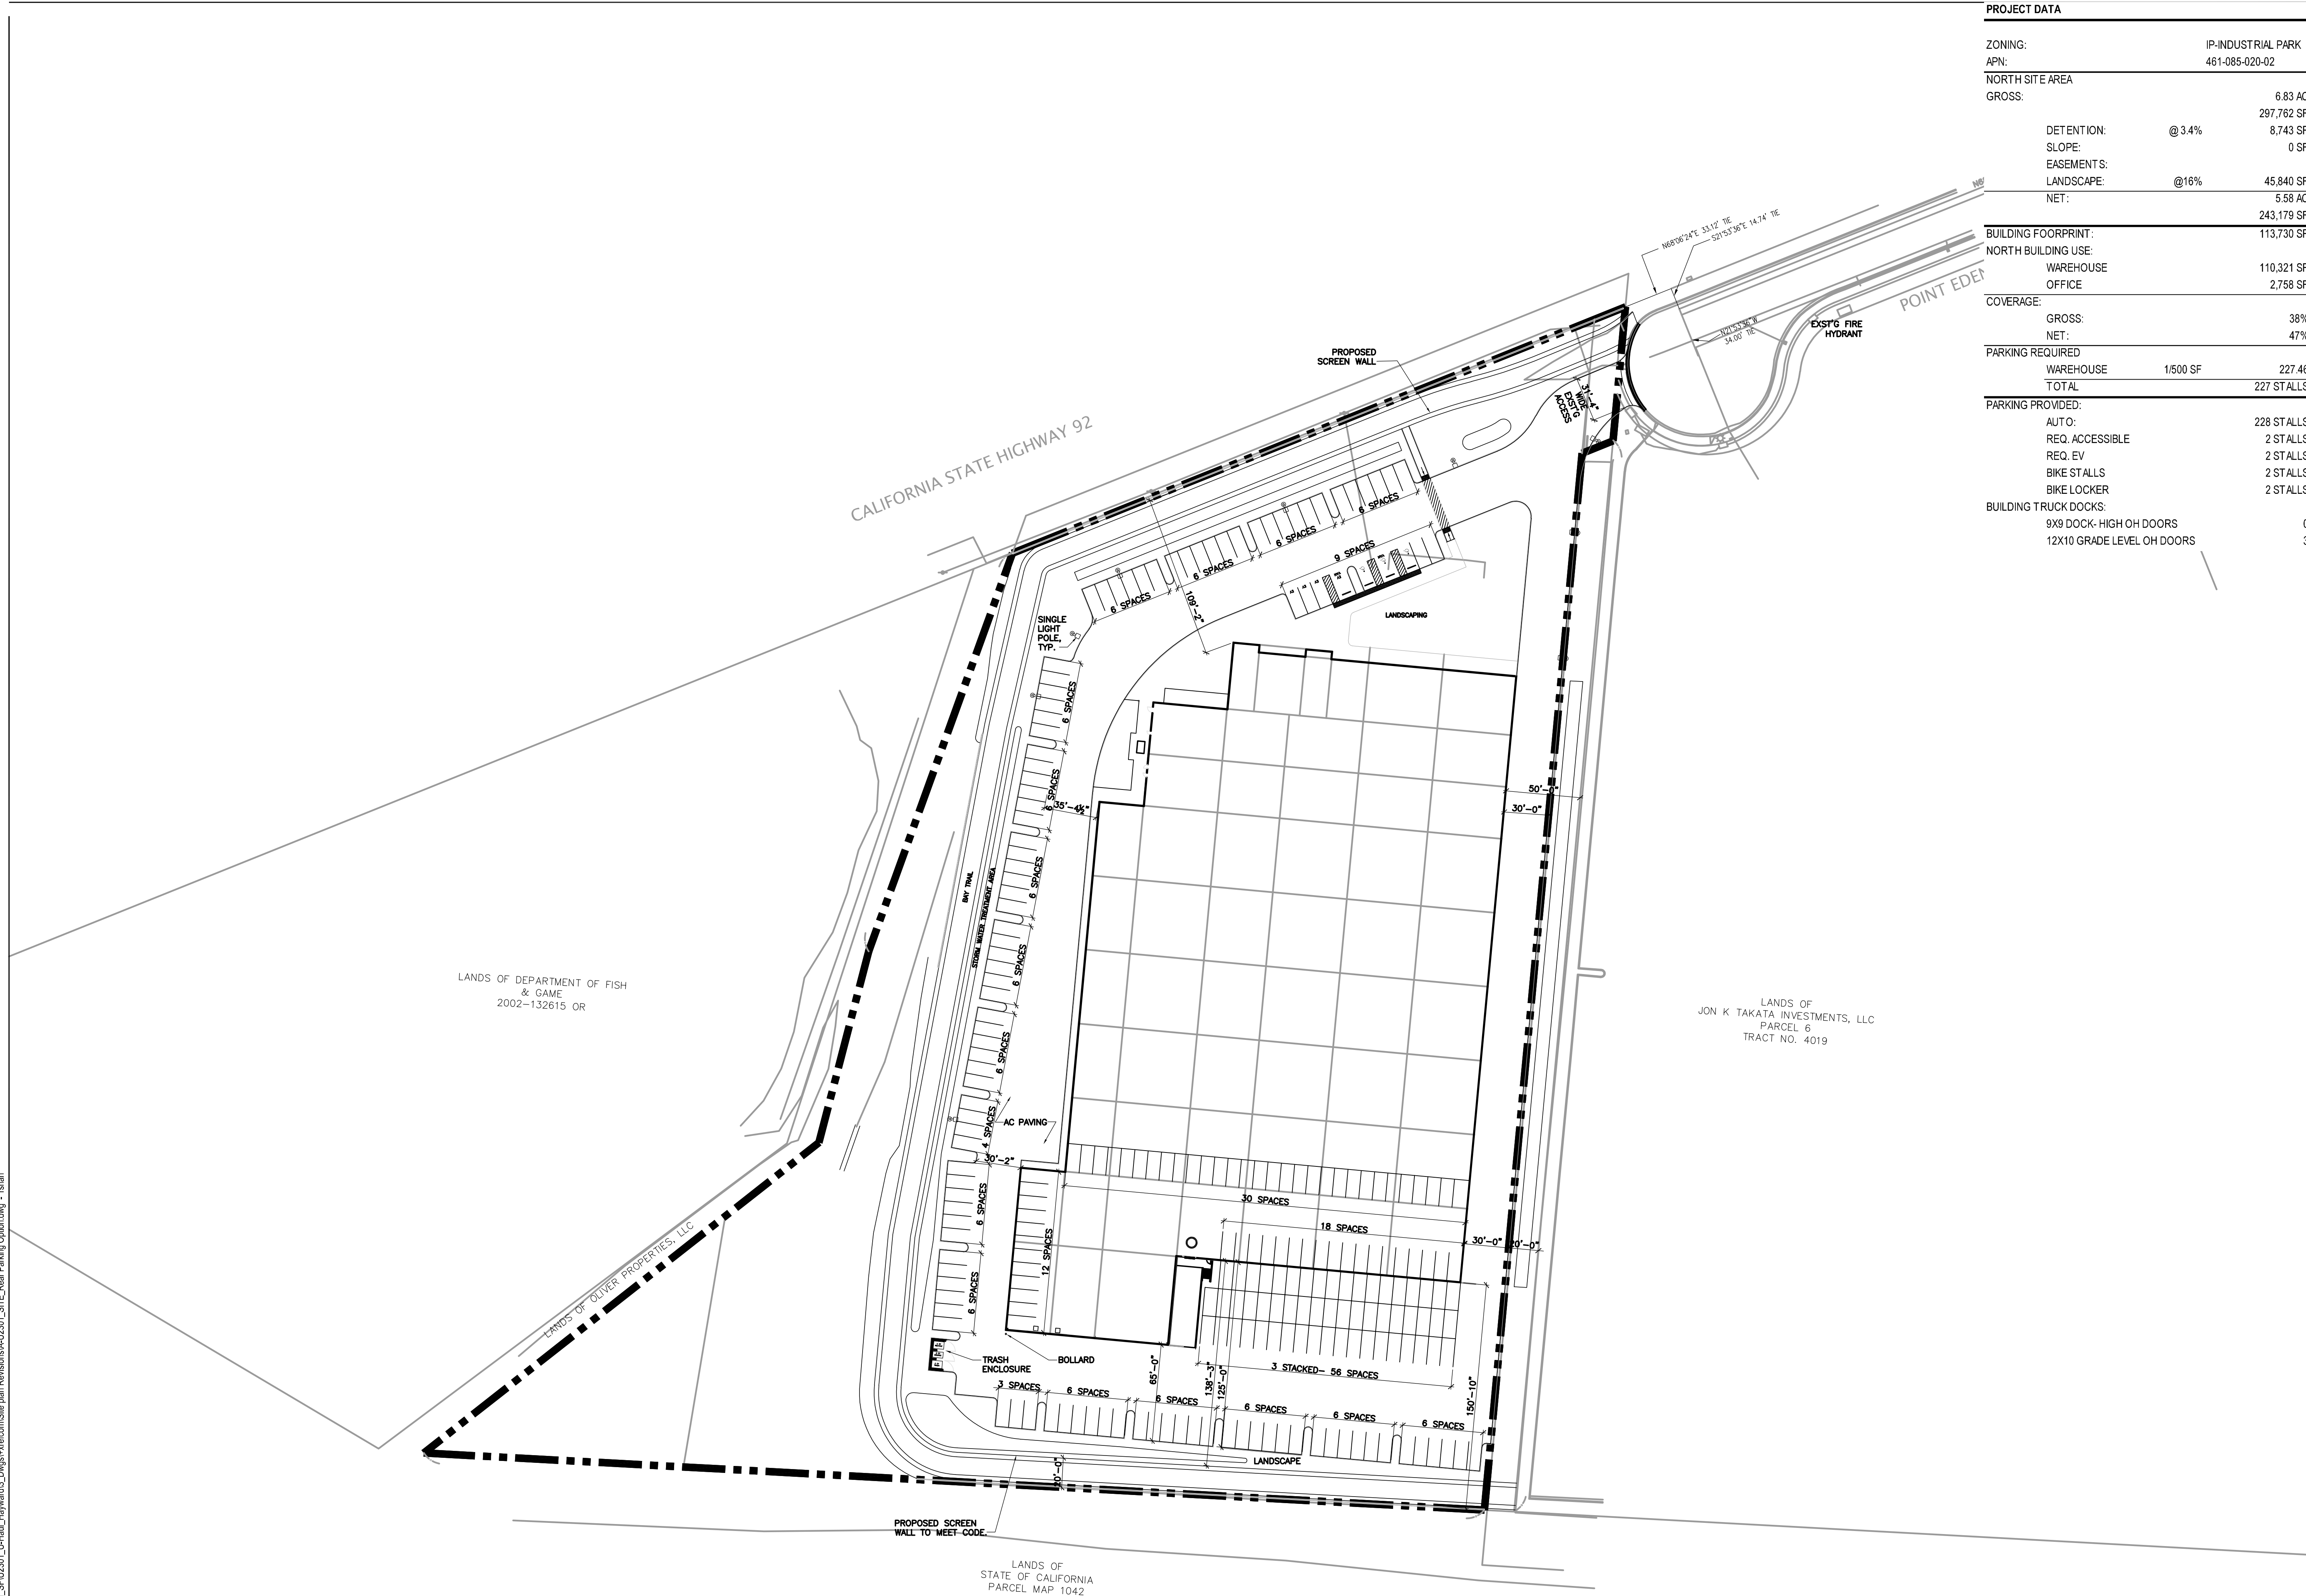

Z:\2019\A19640\DWG\Civil\A19640-CDS.dwg 4-14-20 11:05:10 AM jpalomares

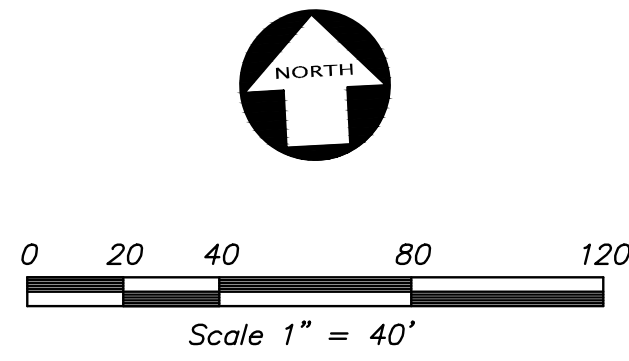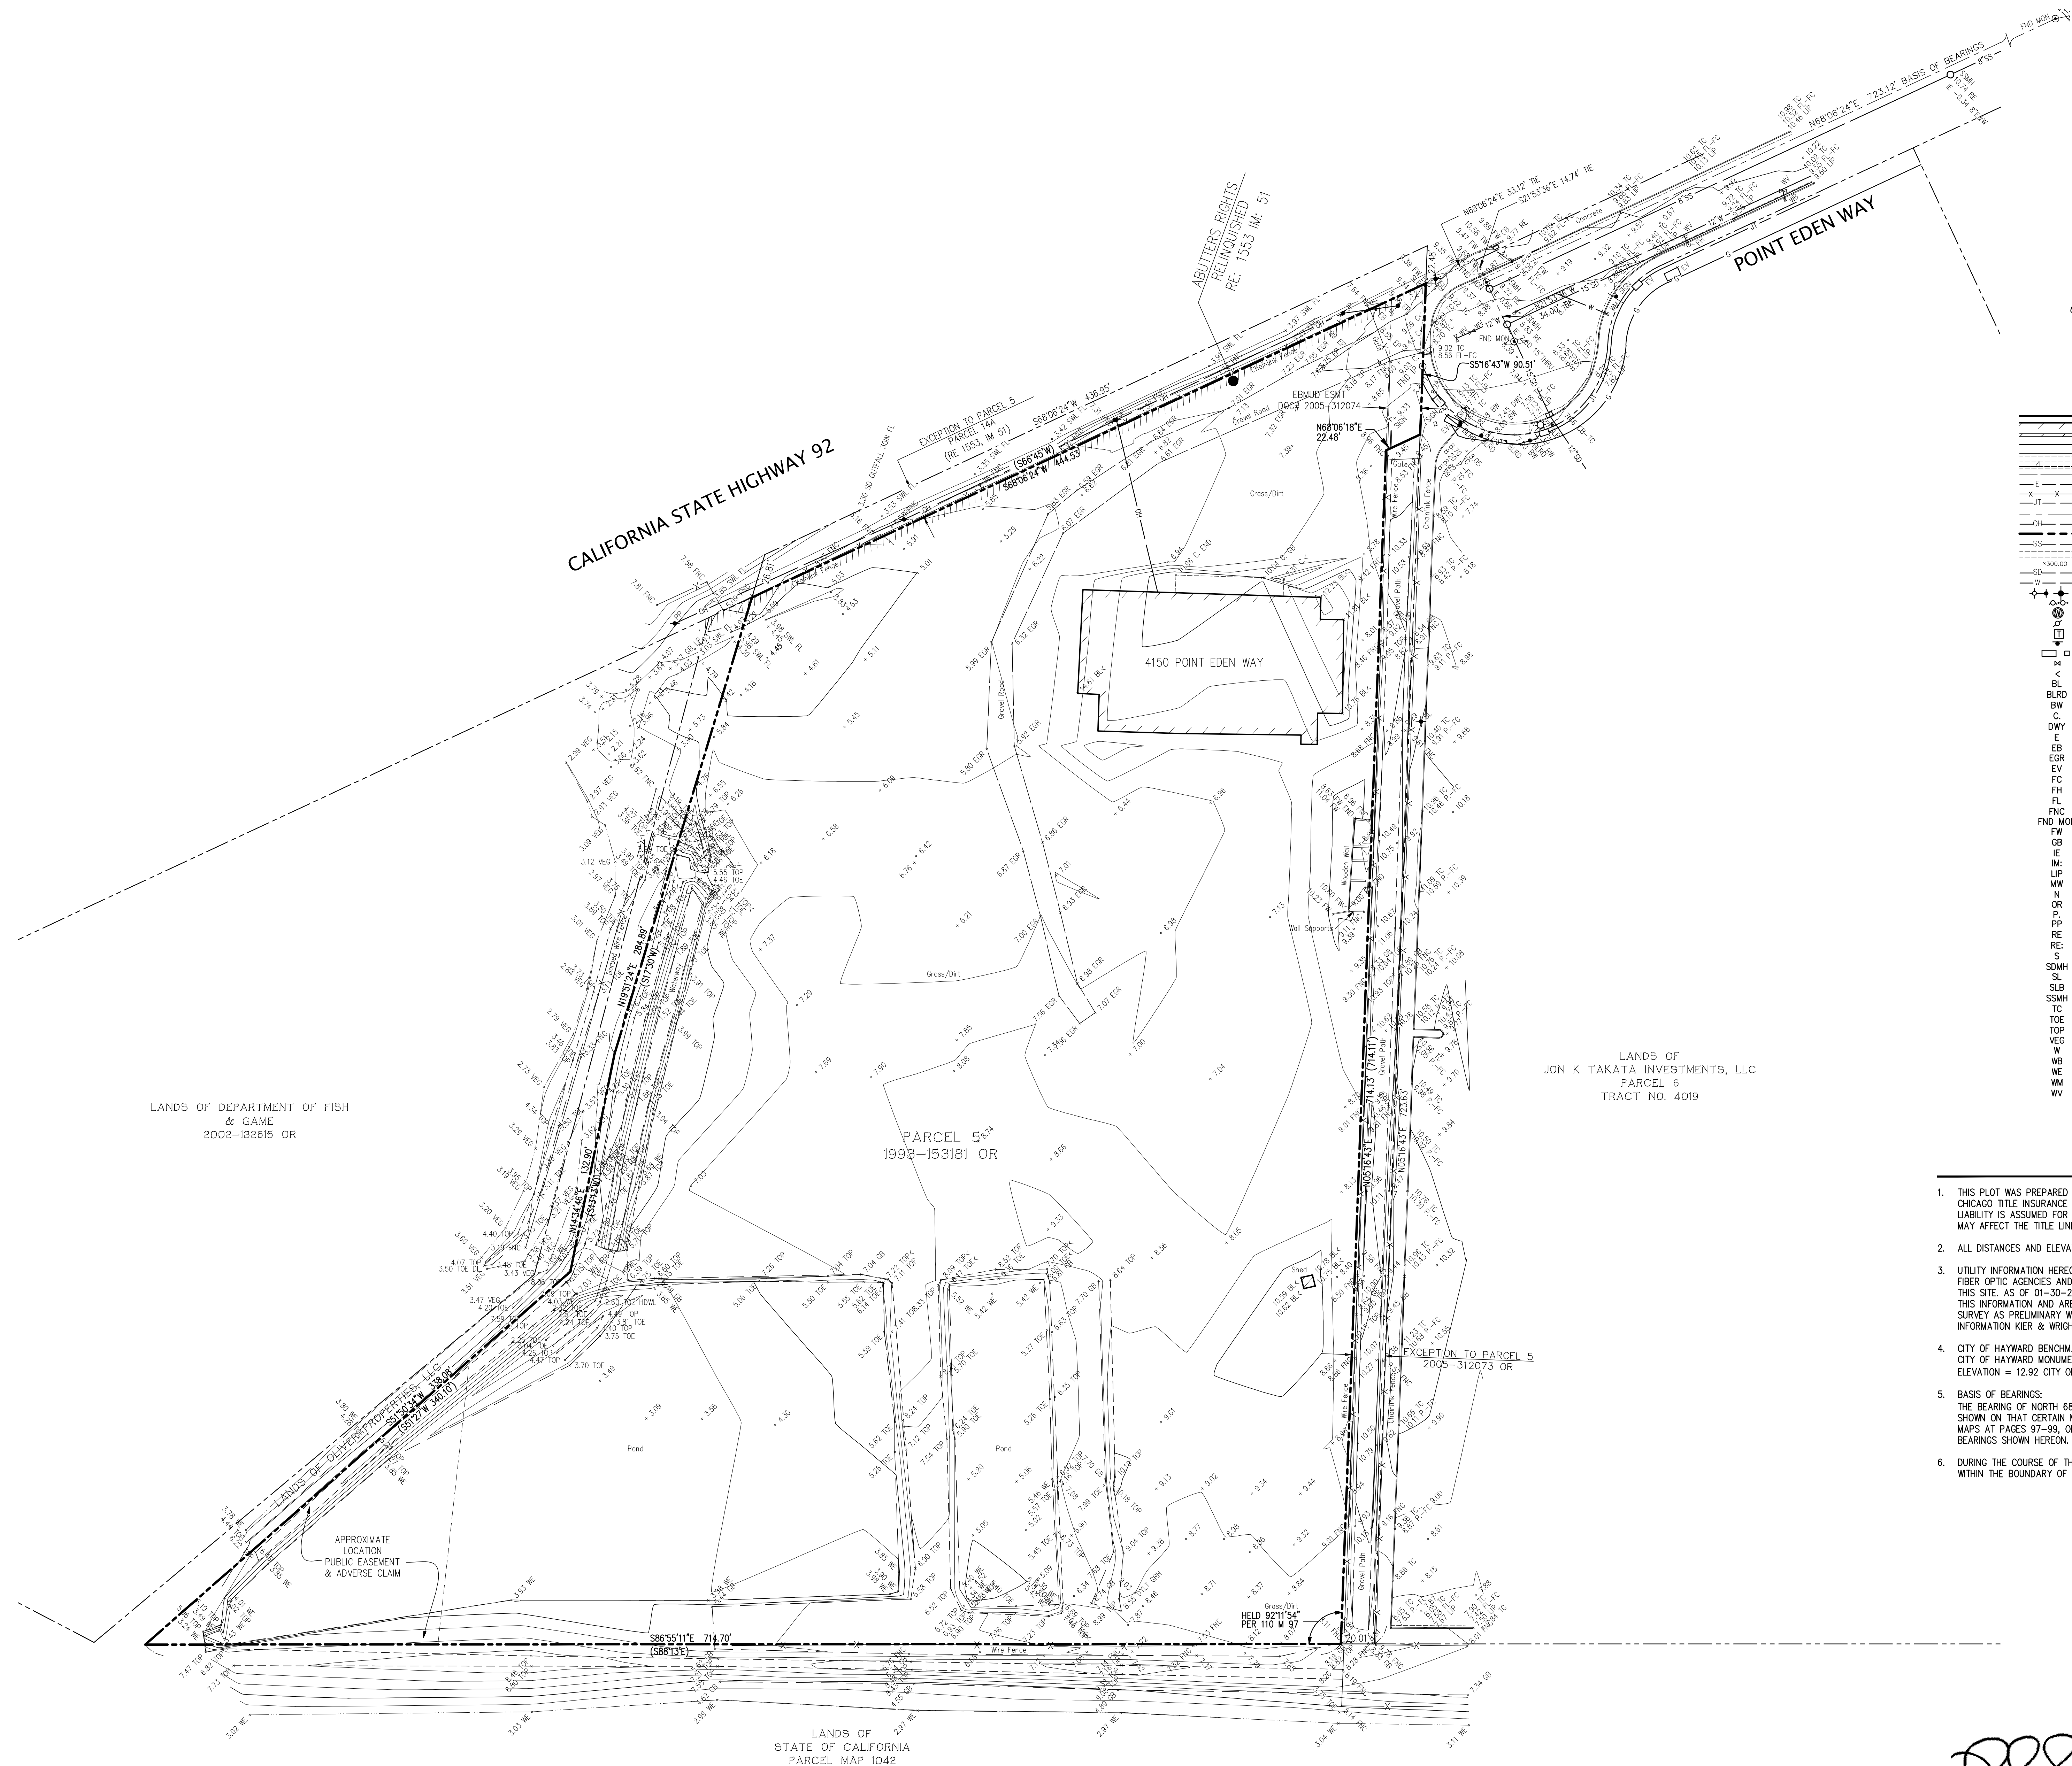

LEGEND

	BUILDING LINE
	CONCRETE/BLOCK/RETAINING WALL
	CONCRETE CURB
	CONCRETE CURB & GUTTER
	DRIVEWAY
	EDGE OF PAVEMENT
	ELECTRIC LINE
	FENCE LINE
	JOINT TRENCH
	MONUMENT/MONUMENT LINE
	OVERHEAD POWER LINE
	PROPERTY LINE
	SANITARY SEWER-MANHOLE & CLEANOUT
	SIDEWALK
	STORM DRAIN-MANHOLE & CATCH BASIN
	WATER LINE & VALVE
	ELECTRIC POLE
	FIRE HYDRANT
	MONITORING WELL
	POWER POLE/JOINT POLE
	TRANSFORMER
	TRAFFIC SIGN
	UTILITY BOX
	WATER VALVE
	ANGLE POINT
	BUILDING LINE
	BOLLARD
	BACK OF WALK
	CONCRETE
	DRIVEWAY
	EAST
	ELECTRIC BOX
	EDGE OF GRAVEL ROAD
	ELECTRICAL VAULT
	FACE OF CURB
	FIRE HYDRANT
	FLOWLINE
	FENCE
	FOUND MONUMENT
	FACE OF WALL
	GRADE BREAK
	INVERT ELEVATION
	IMAGE
	LIP OF GUTTER
	MONITORING WELL
	NORTH
	OFFICIAL RECORDS
	PAVEMENT
	POWER POLE
	RIM ELEVATION
	REEL
	SOUTH
	STORM DRAIN MANHOLE
	STREET LIGHT
	STREET LIGHT BOX
	SANITARY SEWER MANHOLE
	TOP OF CURB
	GRADE BREAK LINE TOE
	GRADE BREAK LINE TOP
	EDGE OF VEGETATION
	WEST
	WATER BOX
	WATER EDGE
	WATER METER
	WATER VALVE

NOTES

- THIS PLOT WAS PREPARED FROM INFORMATION FURNISHED IN A PRELIMINARY TITLE REPORT, PREPARED BY CHICAGO TITLE INSURANCE COMPANY, DATED OCTOBER 24, 2014, NUMBER FWAC-1014002350-KD. NO LIABILITY IS ASSUMED FOR MATTERS OF RECORD NOT STATED IN SAID PRELIMINARY TITLE REPORT THAT MAY AFFECT THE TITLE LINES, OR EXCEPTIONS, OR EASEMENTS OF THE PROPERTY.
- ALL DISTANCES AND ELEVATIONS SHOWN HEREON ARE IN FEET AND DECIMALS THEREOF.
- UTILITY INFORMATION HEREON IS IN PROGRESS AT THIS TIME. A REQUEST WAS MADE TO THE RESPECTIVE FIBER OPTIC AGENCIES AND PG&E FOR INFORMATION REGARDING THE LOCATION OF THEIR FACILITIES ON THIS SITE. AS OF 01-30-2015, THEY HAD NOT RESPONDED WITH THIS INFORMATION. UNTIL WE RECEIVE THIS INFORMATION AND ARE ABLE TO DELINEATE THESE FACILITIES, ALL PARTIES SHOULD CONSIDER THIS SURVEY AS PRELIMINARY WITH REGARDS TO THE LOCATION OF UTILITY FACILITIES. UPON RECEIPT OF THIS INFORMATION KIER & WRIGHT WILL UPDATE THIS SURVEY AND REISSUE IT.
- CITY OF HAYWARD BENCHMARK:
CITY OF HAYWARD MONUMENT DISK AT EDEN LANDING ROAD AND POINT EDEN WAY.
ELEVATION = 12.92 CITY OF HAYWARD DATUM (NGVD 1929)
- BASIS OF BEARINGS:
THE BEARING OF NORTH 68° 06' 24" EAST TAKEN ON THE MONUMENT LINE OF POINT EDEN WAY AS SHOWN ON THAT CERTAIN MAP OF TRACT 4019, FILED FOR RECORD ON JUNE 28, 1979, IN BOOK 110 OF MAPS AT PAGES 97-99, OFFICIAL RECORDS OF ALAMEDA COUNTY WAS TAKEN AS THE BASIS FOR ALL BEARINGS SHOWN HEREON.
- DURING THE COURSE OF THIS SURVEY, THERE WAS NO OBSERVED EVIDENCE OF WETLANDS MARKERS WITHIN THE BOUNDARY OF THE SUBJECT PROPERTY.

PREPARED BY OR UNDER THE SUPERVISION OF
RODNEY A. STEWART II P.L.S. 9225
LICENSE EXPIRES: 9-30-17

06/22/2016
DATE



TOPOGRAPHIC SURVEY
OF
4150 POINTE EDEN WAY
FOR
U-HAUL, INC.

DATE	APRIL, 2020
SCALE	1" = 40'
DESIGNER	KS/SS
DRAWN BY	TB/JTQ
JOB NO.	A19640
SHEET	C1.0
OF	8 SHEETS





KIER+WRIGHT
2850 Collier Canyon Road
Livermore, CA 94551
Phone: (925) 245-9288
www.kierwright.com

CALIFORNIA


HAYWARD.

Z:\2019\A19640\DWG\CIVIL\A19640-CDS-CP.dwg, 4-14-20, 11:33:41 AM, jgullentong

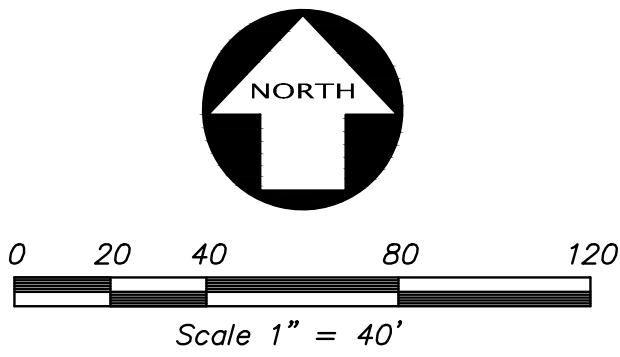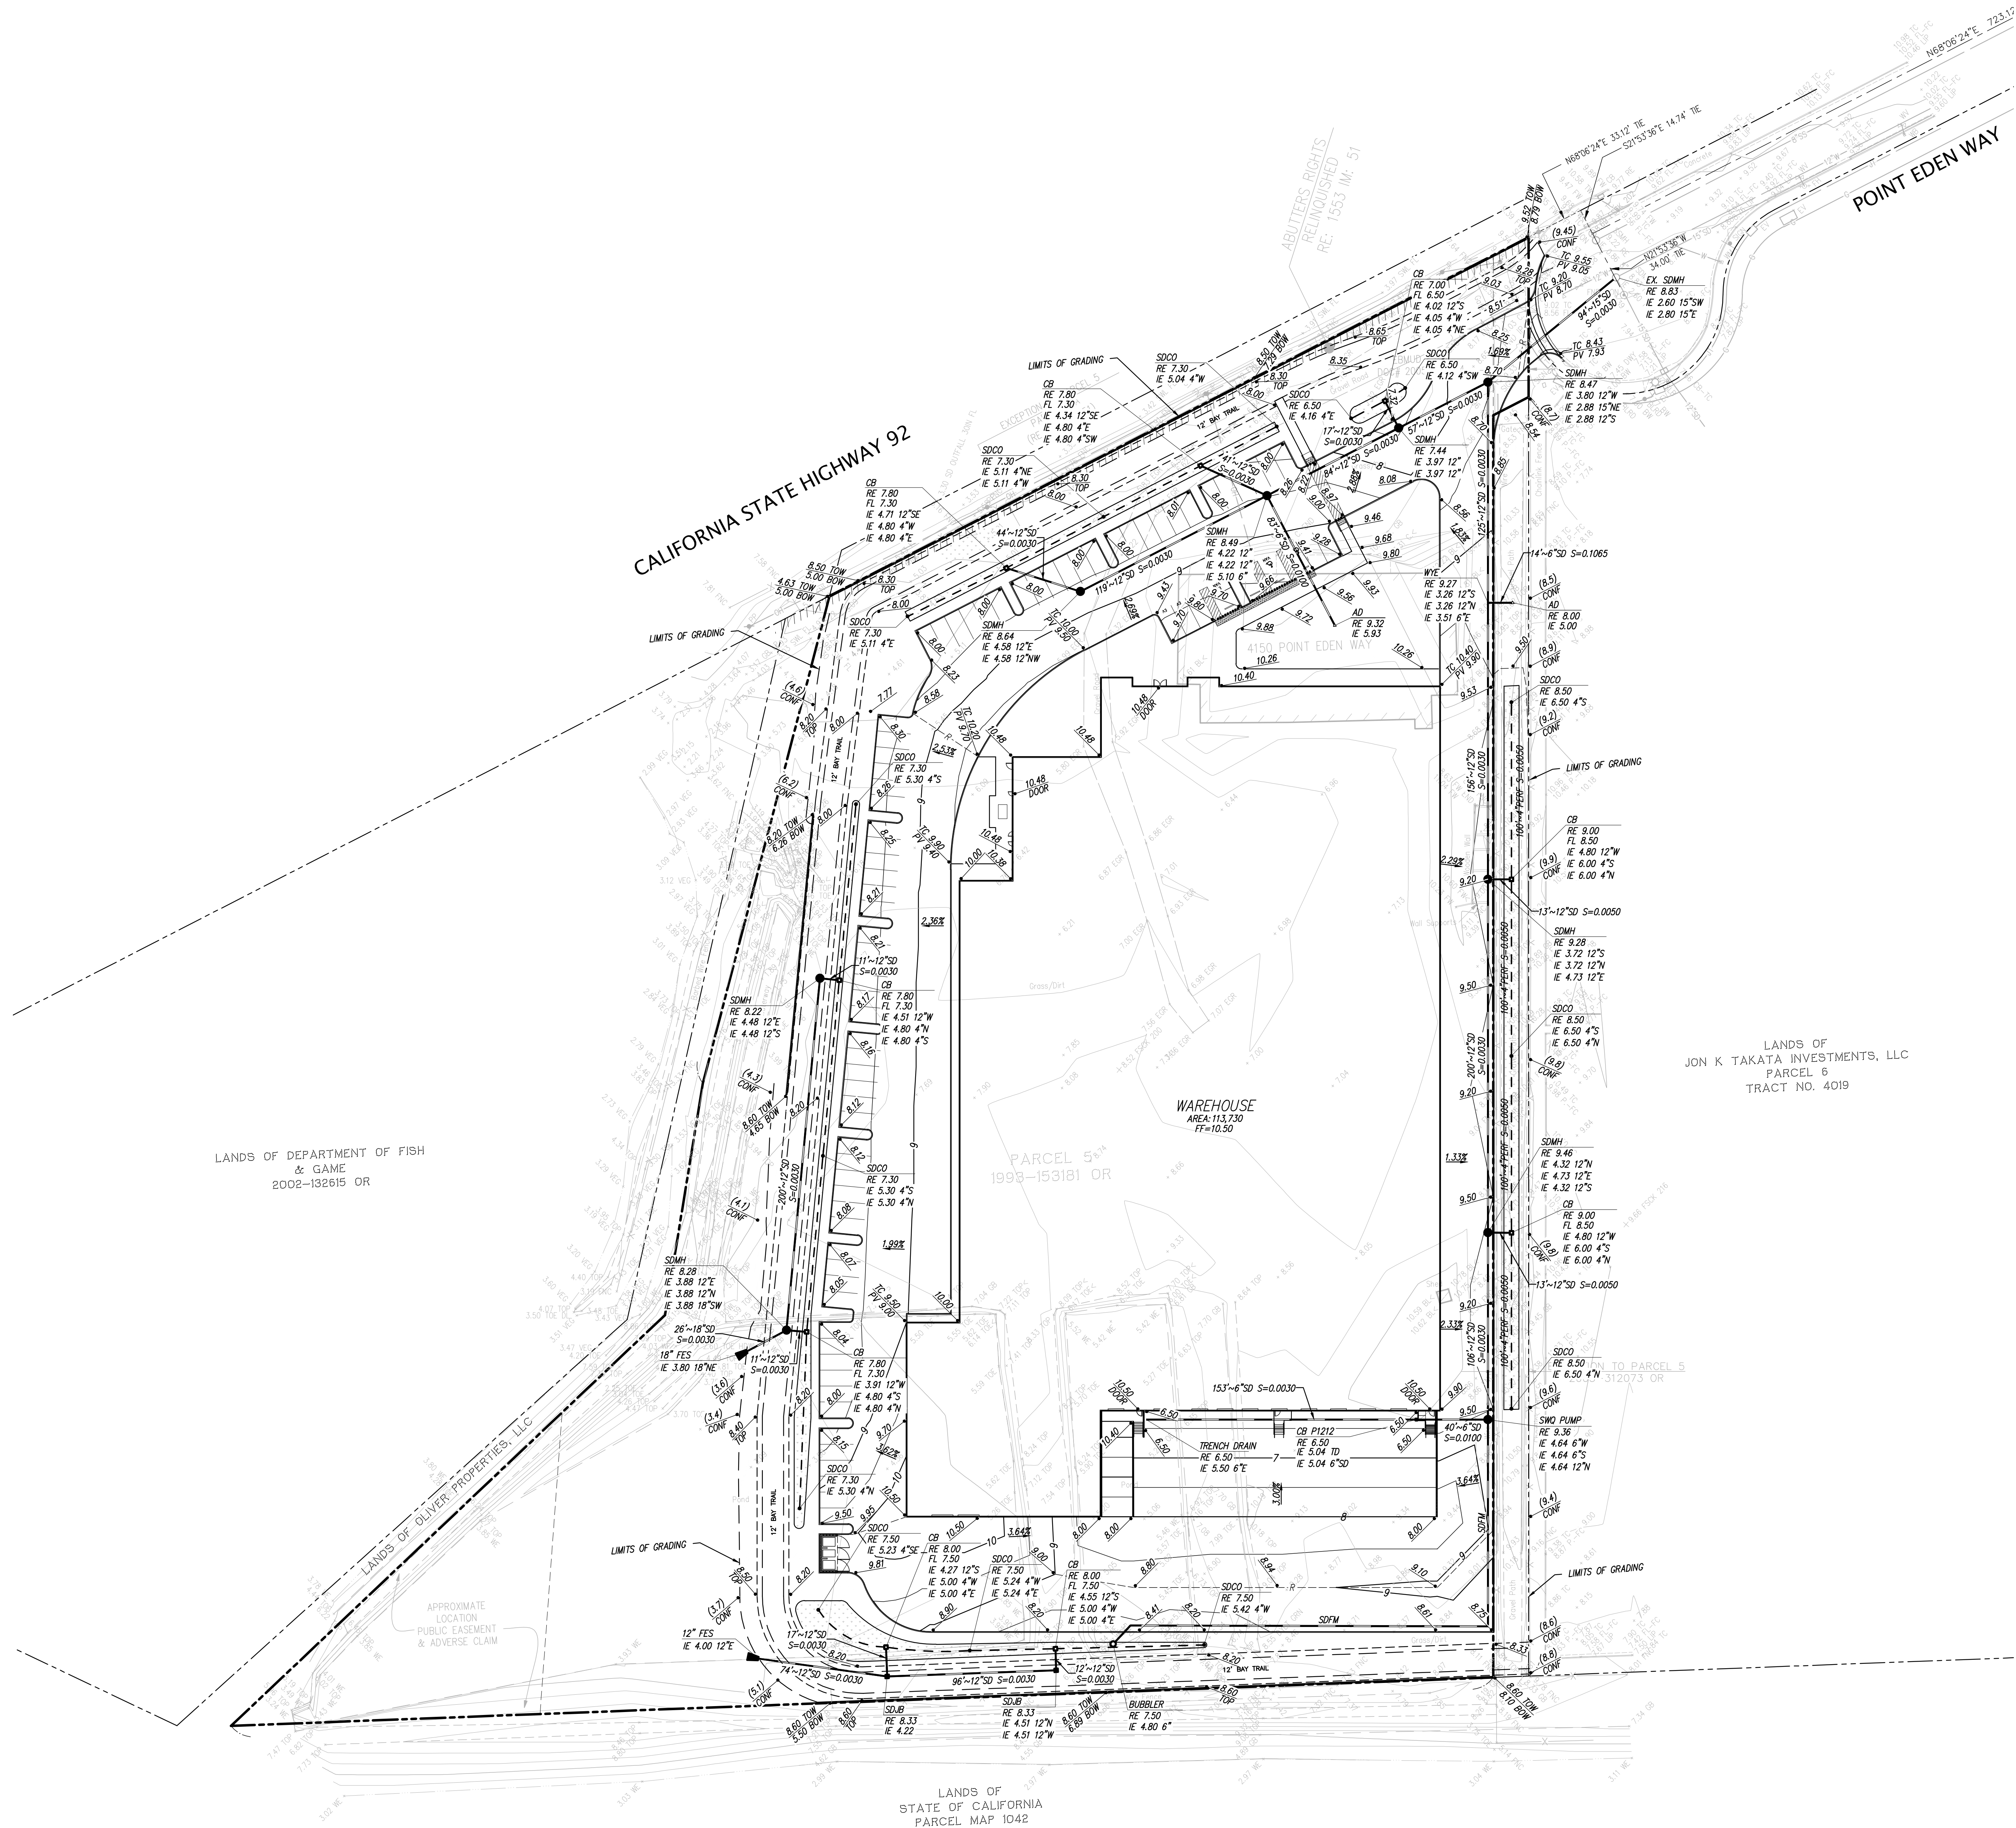

LEGEND

PROPOSED	EXISTING	
		ASPHALT BERM
		BLOCK/RETAINING WALL
		BUILDING LINE
		FLUSH CONCRETE CURB
		CONCRETE CURB CUT
		CONCRETE CURB & GUTTER
		CONTOUR LINE
		DRIVEWAY
		EDGE OF PAVEMENT
		FENCE LINE
		LOT LINE
		MONUMENT/MONUMENT LINE
		PERFORATED STORM DRAIN PIPE
		PROPERTY LINE
		RAINWATER LEADER
		SIDE WALL
		STORM DRAIN-MANHOLE & CATCH BASIN
		THRU CURB DRAIN
		SPOT ELEVATION
		TRAFFIC SIGN
		TREE
		UTILITY BOX
		AREA DRAIN
		BACK OF WALK
		BUILDING
		BUILDING LINE
		CATCH BASIN
		CLEANOUT TO GRADE
		CONCRETE
		DOOR
		DOWN SPOUT
		DUCTILE IRON PIPE
		EASEMENT
		EDGE OF WALK
		FACE OF BERM
		FACE OF CURB
		FACE OF WALL
		FINISHED FLOOR
		FLOW LINE
		GRADE BREAK
		HIGH POINT
		INVERT ELEVATION
		LOW POINT
		LIGHT
		OVERFLOW
		PAVEMENT
		RAINWATER LEADER
		RIDGE
		RIM ELEVATION
		ROOF DRAIN
		STORM DRAIN JUNCTION BOX
		STORM DRAIN MANHOLE
		SWALE
		TOP OF BERM
		TOP OF CURB
		TOP OF WALL
		TRANSFORMER
		TRASH ENCLOSURE
		BIO-FILTRATION SWALE

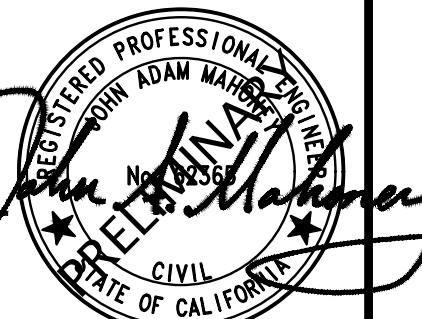

KIER+WRIGHT



2850 Collier Canyon Road
Livermore, CA 94551

Phone: (925) 245-9788
www.kierwright.com

PRELIMINARY GRADING AND DRAINAGE PLAN
OF
4150 POINTE EDEN WAY
FOR
U-HAUL, INC.

CALIFORNIA

HAYWARD.



DATE	APRIL, 2020
SCALE	1" = 40'
DESIGNER	KS/SS
DRAWN BY	TB/JTQ
JOB NO.	A19640
SHEET	C2.0
OF	8 SHEETS

Catchbasin Insert, Full Capture Device

KS-1 Flo Gard Plus catchbasin filter Inserts, combination inlet style, stainless steel only (C3)
Drop in Basket



Company Contact: Krislar Enterprises, Inc., Santa Rosa, CA Sales contact: Sue Lillo, 800-579-8819 sue@krislar.com http://www.krislar.com	
Storage capacity: 1.8, 2.7 or 4.1 cubic feet depending on size of inlet	Replacement Parts: Available
Vendor's maintenance estimate: "Depends on the amount of runoff, pollutant loading and interference from debris"	Warranty: 5 years
Material: 304 stainless steel	Delivery Time: Typically 1 week for standard products; 3 weeks for customized products
Pricing: See over.	
Installed: FloGard inserts are in use in County of Sonoma, Alameda County Transit, Santa Clara Valley Transit Authority, Riverside County TMA	

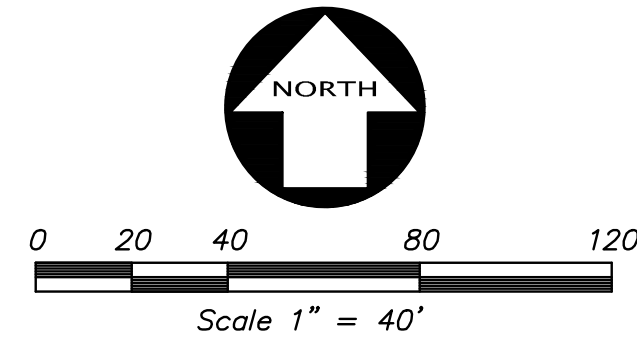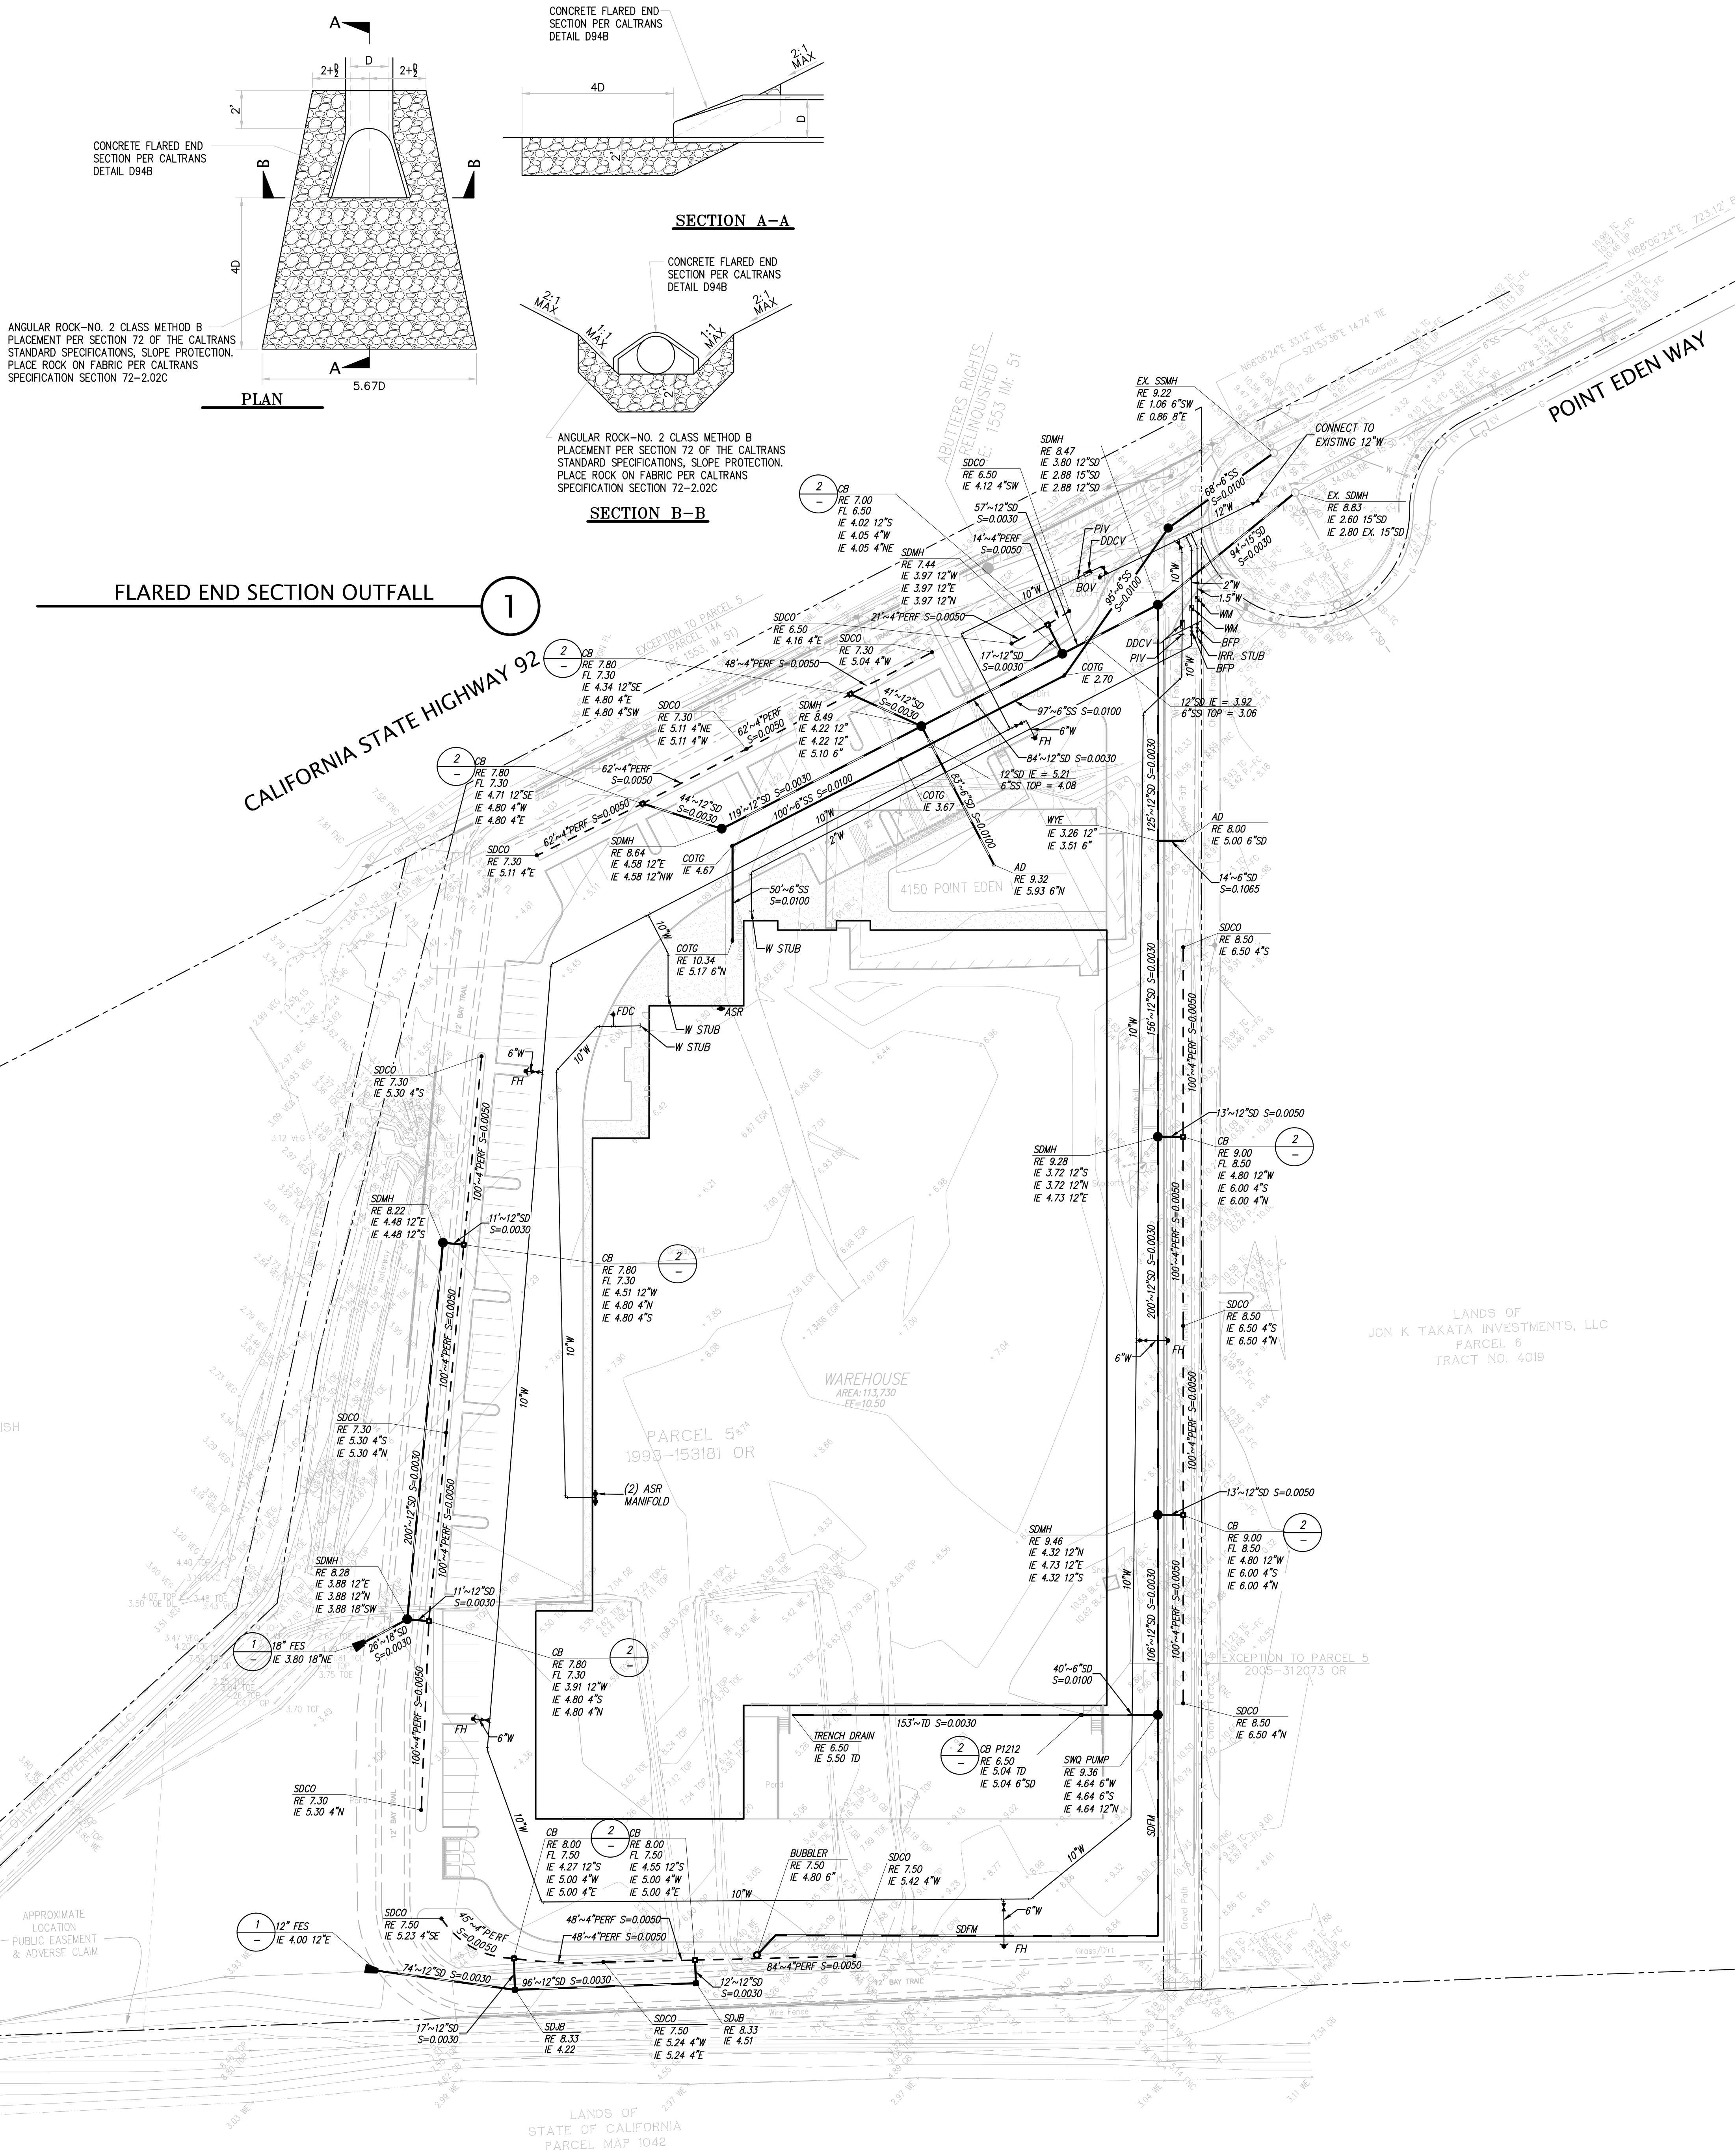

LEGEND

PROPOSED	EXISTING	
		ASPHALT BERM
		BUILDING LINE
		CENTER LINE
		CONCRETE CURB
		CONCRETE CURB & GUTTER
		CONTOUR LINE
		DRIVEWAY
		EDGE OF PAVEMENT
		ELECTRIC LINE
		FENCE LINE
		FIRE SERVICE & VALVE
		FIBER OPTICS LINE
		GAS LINE - VALVE & METER
		GUARD RAIL
		LOT LINE
		MONUMENT/MANHOLE LINE
		OVERHEAD POWER LINE
		PROPERTY LINE
		SANITARY SEWER - MANHOLE & CLEANOUT
		SIDEWALK
		SPOT ELEVATION
		STORM DRAIN - MANHOLE & CATCH BASIN
		THRU CURB DRAIN
		TELEPHONE LINE
		WATER LINE & VALVE
		BACKFLOW PREVENTION DEVICE
		ELECTROLINER
		FIRE HYDRANT
		POST INDICATOR VALVE
		POWER POLE/JOINT POLE
		TRANSFORMER
		TRAFFIC SIGN
		UTILITY BOX
		AREA DRAIN
		AIR VALVE
		AIR VALVE POST
		AUTOMATIC SPRINKLER RISER
		BACKFLOW PREVENTION DEVICE
		BLOWOFF VALVE
		CABLE TELEVISION BOX
		CATCH BASIN
		CLEANOUT TO GRADE
		DOWN SPOUT
		ELECTROLYSIS TEST STATION
		FINISHED FLOOR
		FIRE HYDRANT
		FLOW LINE
		FIBER OPTICS MARKER
		GAS LINE MARKER
		GAS METER
		GAS VALVE
		GUY ANCHOR
		INVERT ELEVATION
		IRRIGATION BOX
		JOINT POWER POLE
		LIGHT
		PAC BELL MANHOLE
		POINT OF CONNECTION
		POST INDICATOR VALVE
		POWER POLE
		RAIN WATER LEADER
		RELEASE VALVE POST
		RIM ELEVATION
		SANITARY SEWER CLEANOUT
		SANITARY SEWER MANHOLE
		SPRINT MANHOLE
		STORM DRAIN JUNCTION BOX
		STREET LIGHT BOX
		TELEPHONE BOX
		TELEPHONE MANHOLE
		TRAFFIC SIGNAL BOX
		TRAFFIC SIGNAL POLE
		WATER BOX
		WATER METER
		WATER VALVE



KS-1 TRASH CAPTURE DROP INLET

2


PRELIMINARY UTILITY PLAN
OF
4150 POINTE EDEN WAY
FOR
U-HAUL, INC.

DATE	APRIL, 2020
SCALE	1" = 40'
DESIGNER	KS/SS
DRAWN BY	TB/JTQ
JOB NO.	A19640
SHEET	C3.0
OF	8 SHEETS

Z:\2019\A19640\DWG\CIVIL\A19640-CDS-SMA.dwg 4-14-20 11:07:22 AM julliantang

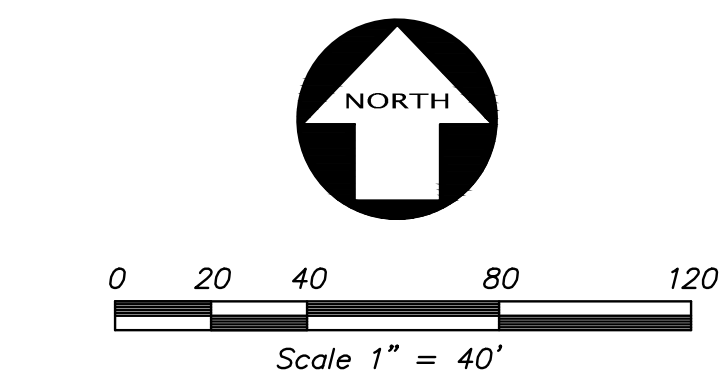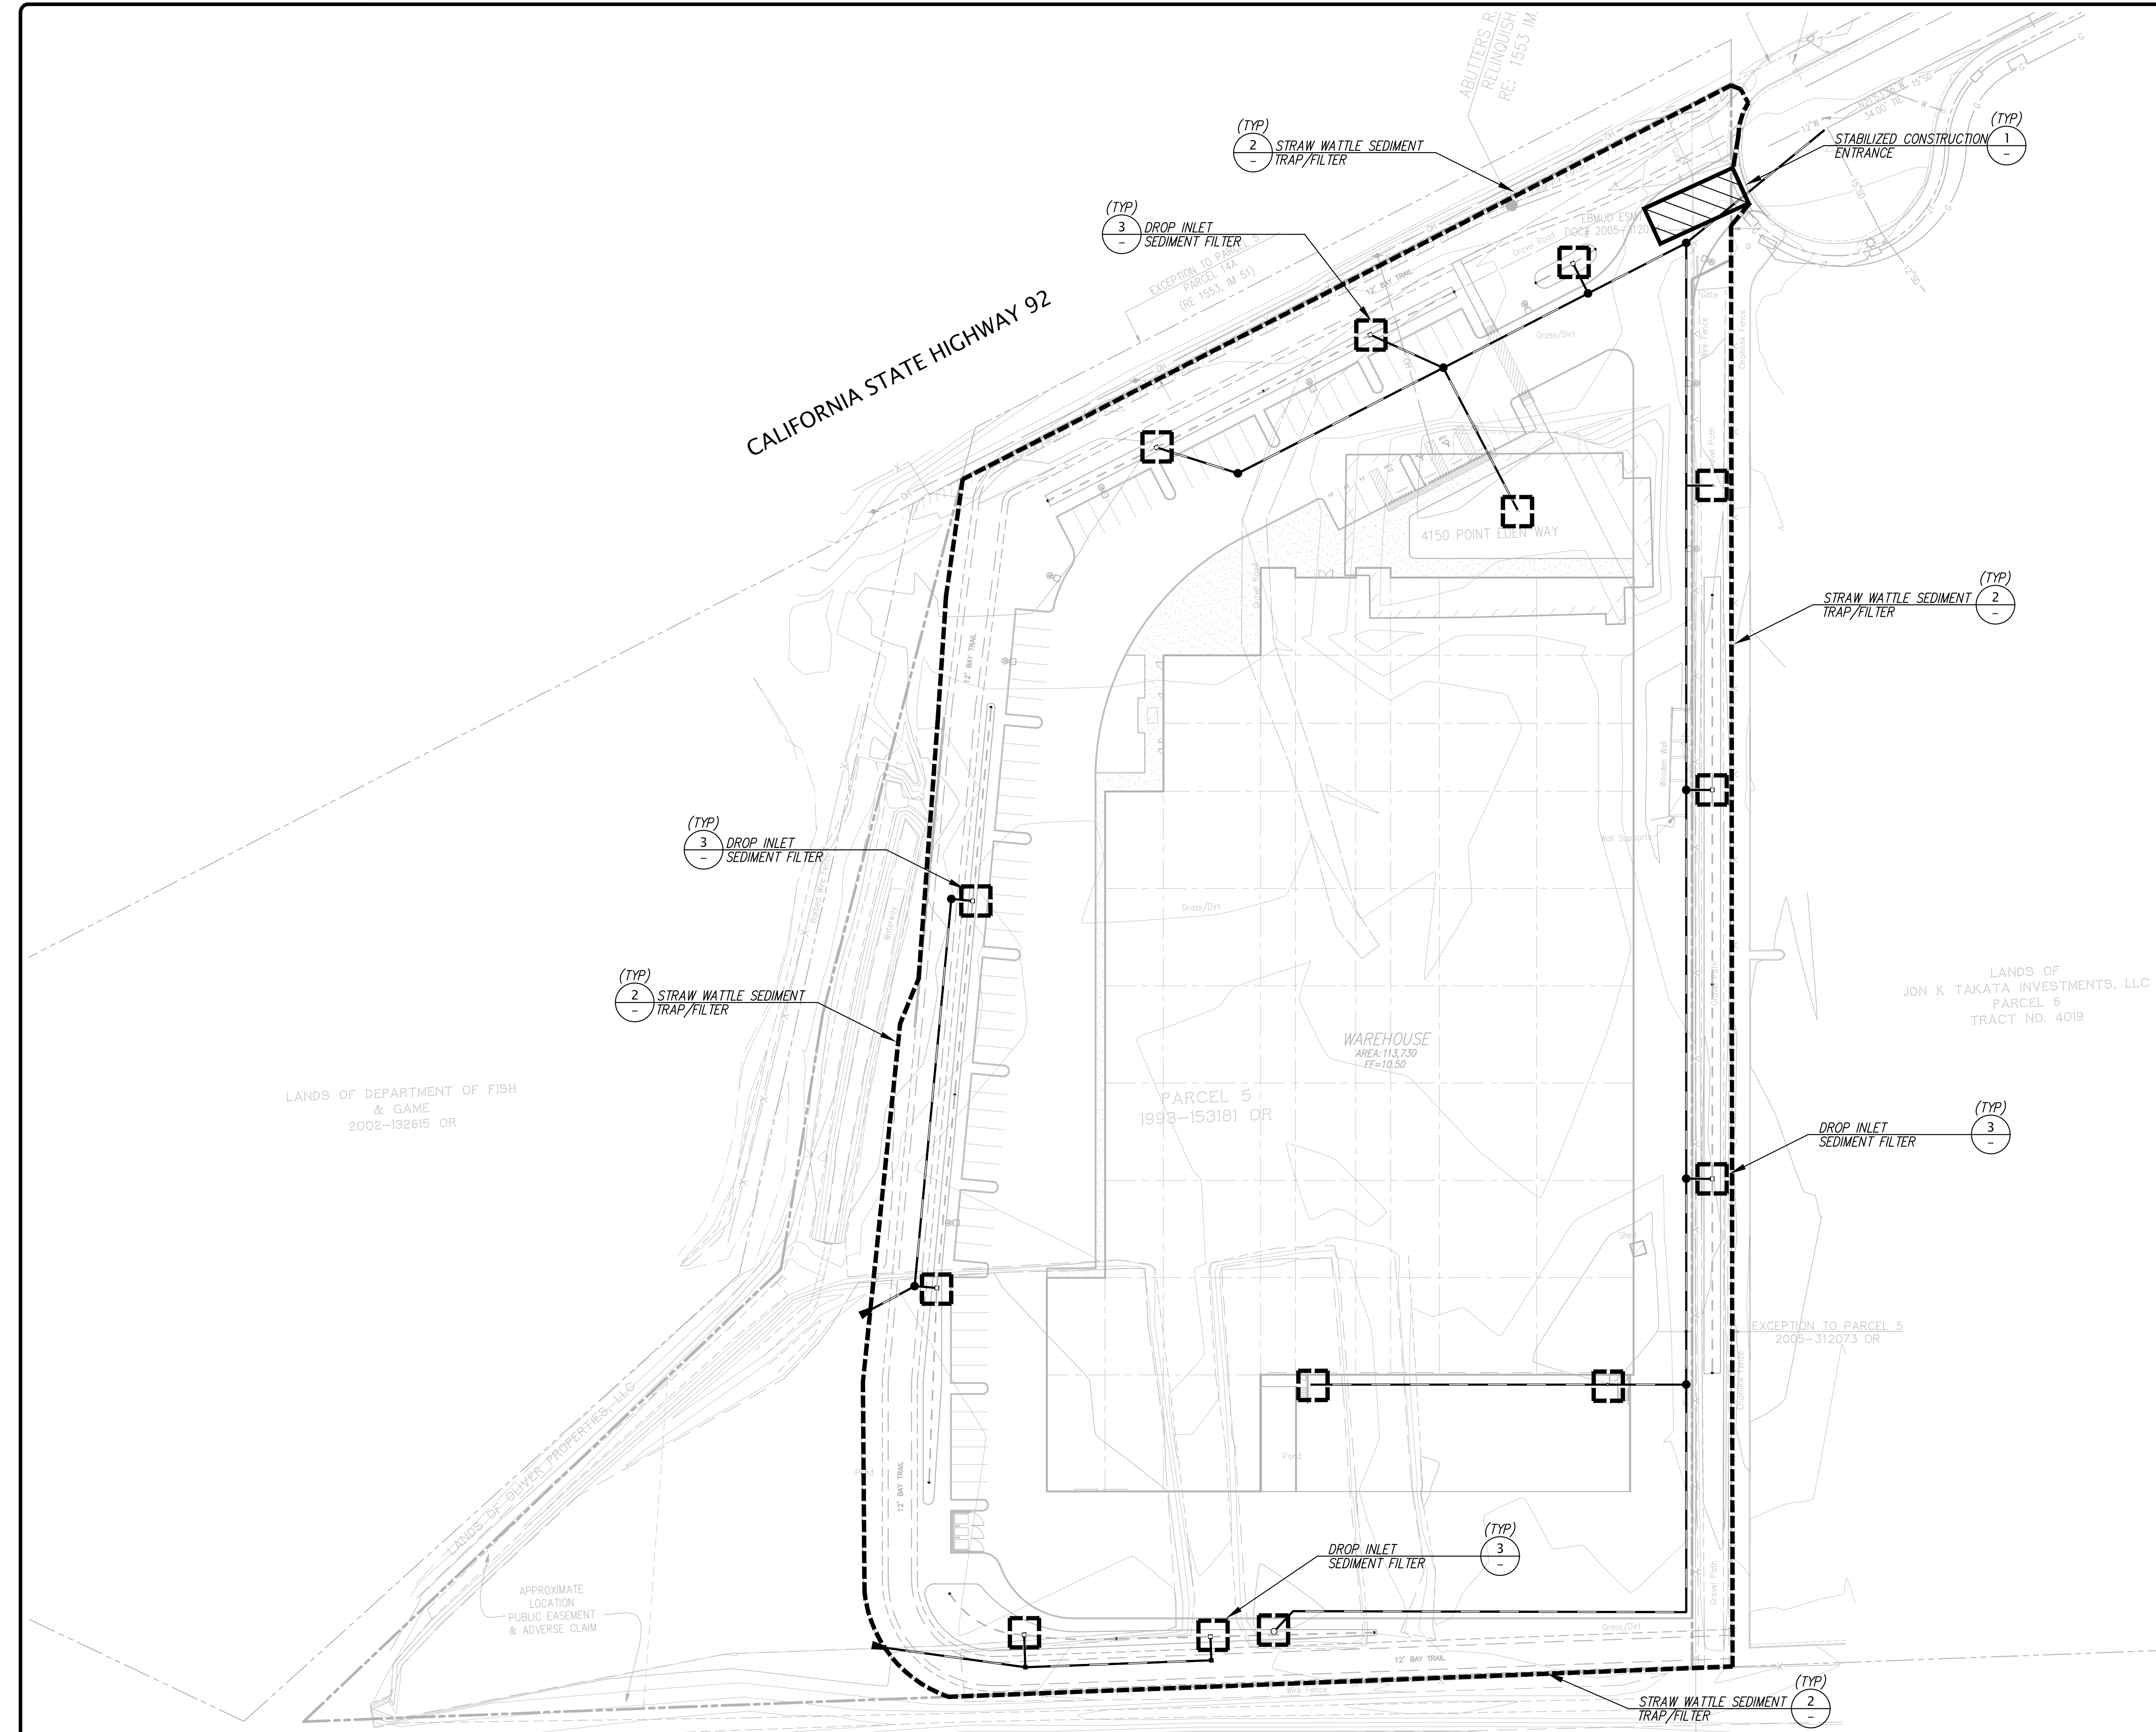


LEGEND	
	(1) STABILIZED CONSTRUCTION ENTRANCE
	(2) STRAW WATTLE SEDIMENT TRAP/FILTER
	(3) DROP INLET SEDIMENT FILTER

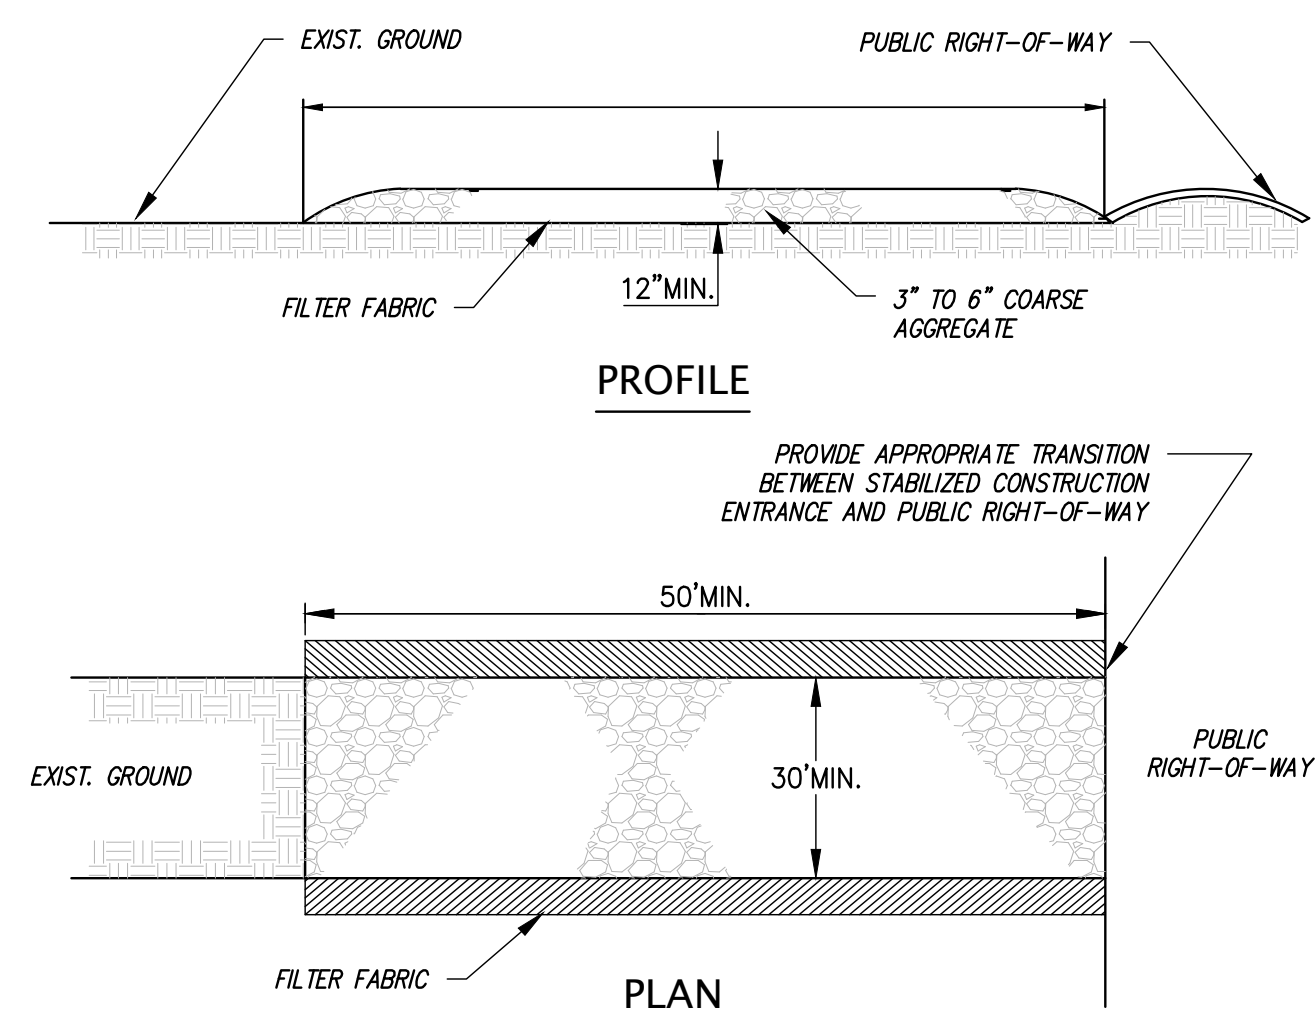


STABILIZED CONSTRUCTION ENTRANCE
NOT TO SCALE

1

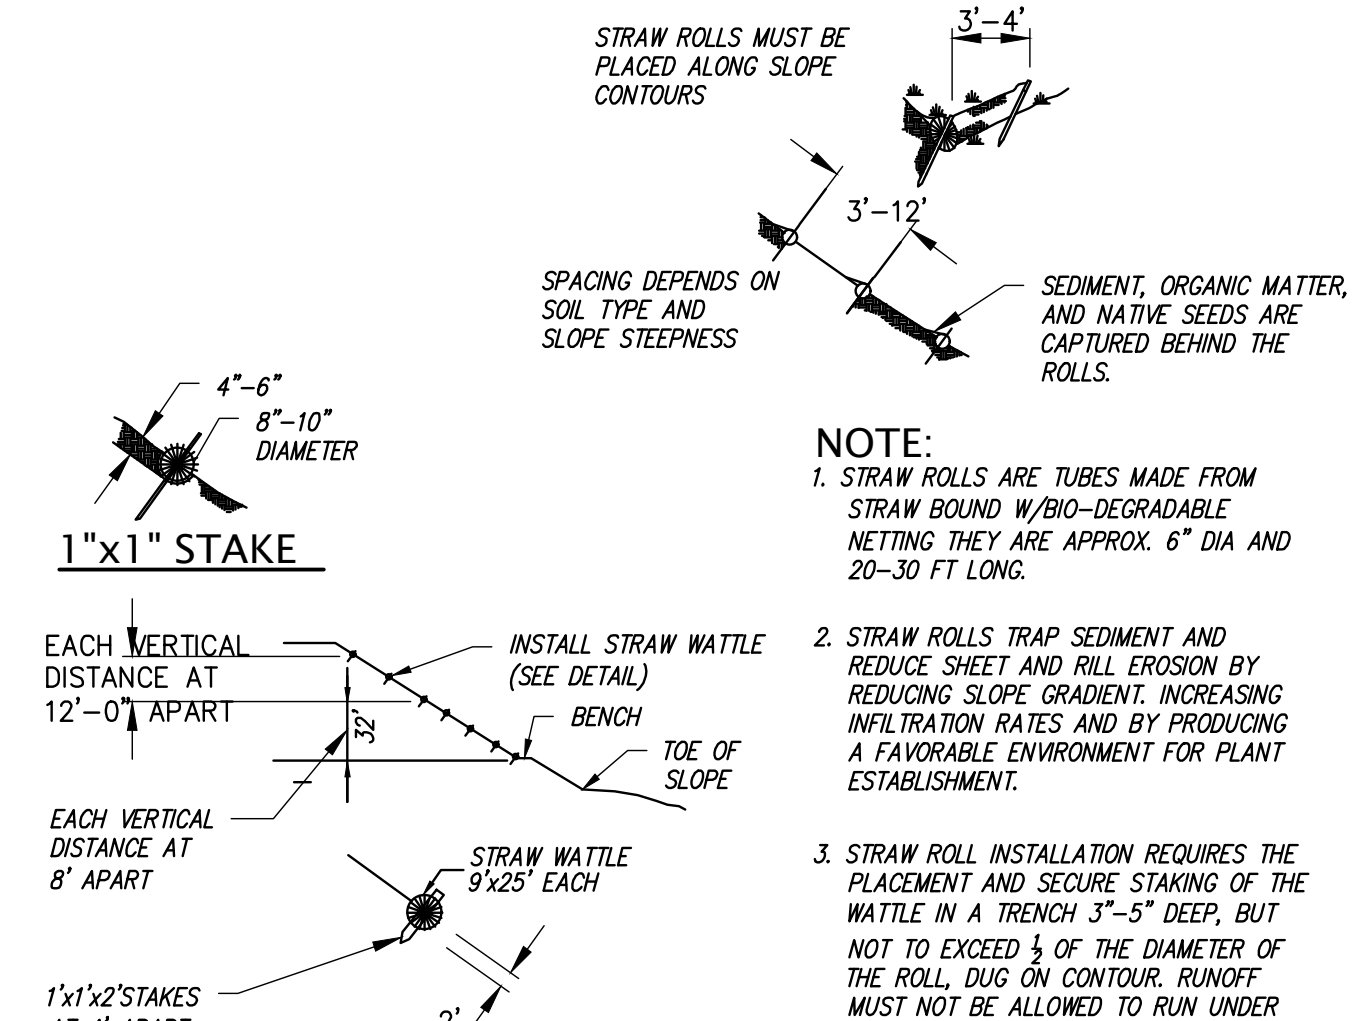

STRAW WATTLE
NOT TO SCALE

2

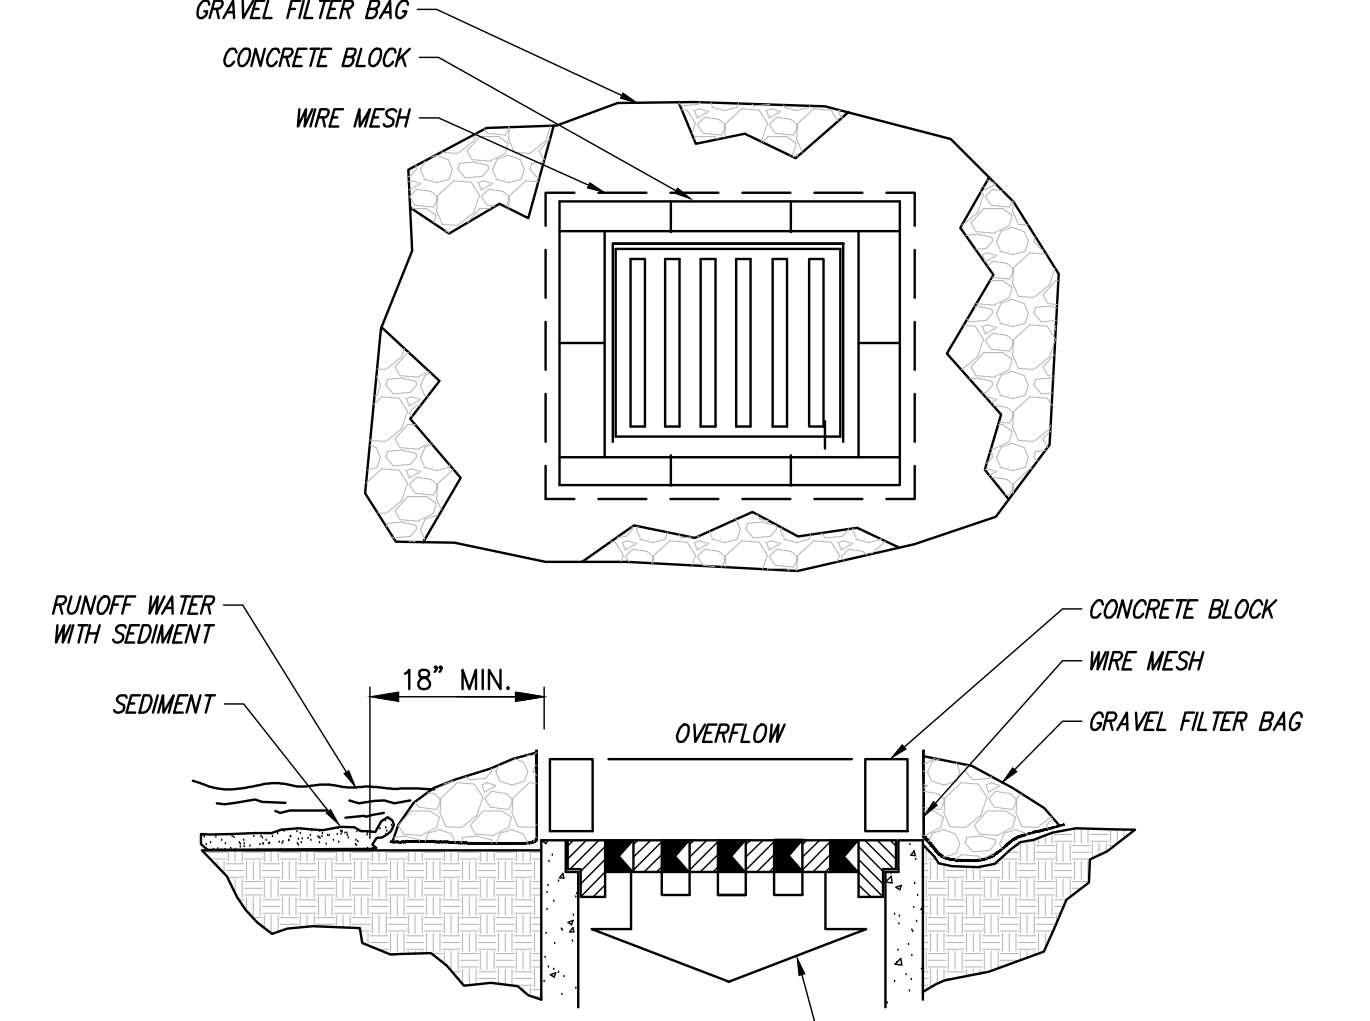

DROP INLET SEDIMENT FILTER
NOT TO SCALE

3

DATE	APRIL, 2020
SCALE	1" = 40'
DESIGNER	KS/SS
DRAWN BY	TB/JTQ
JOB NO.	A19640
SHEET	C4.0
OF	8 SHEETS



KIER+WRIGHT
2850 Collier Canyon Road
Livermore, CA 94551
Phone: (925) 245-9788
www.kierwright.com

REGISTERED PROFESSIONAL
JASON ADAM WRIGHT
No. 82365
CIVIL
STATE OF CALIFORNIA


EROSION CONTROL PLAN
OF
4150 POINTE EDEN WAY
FOR
U-HAUL, INC.

CALIFORNIA
HAYWARD.

PROPOSED LAND SWAP EXHIBIT

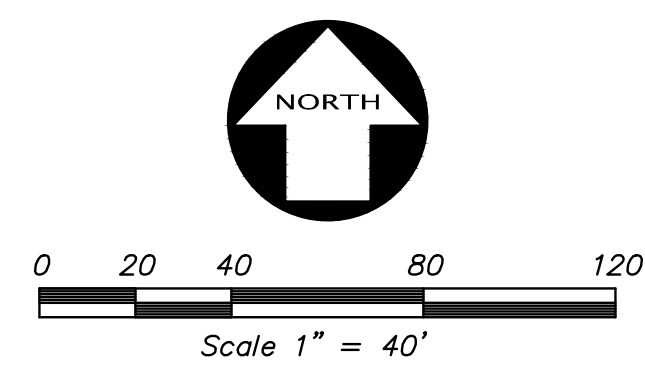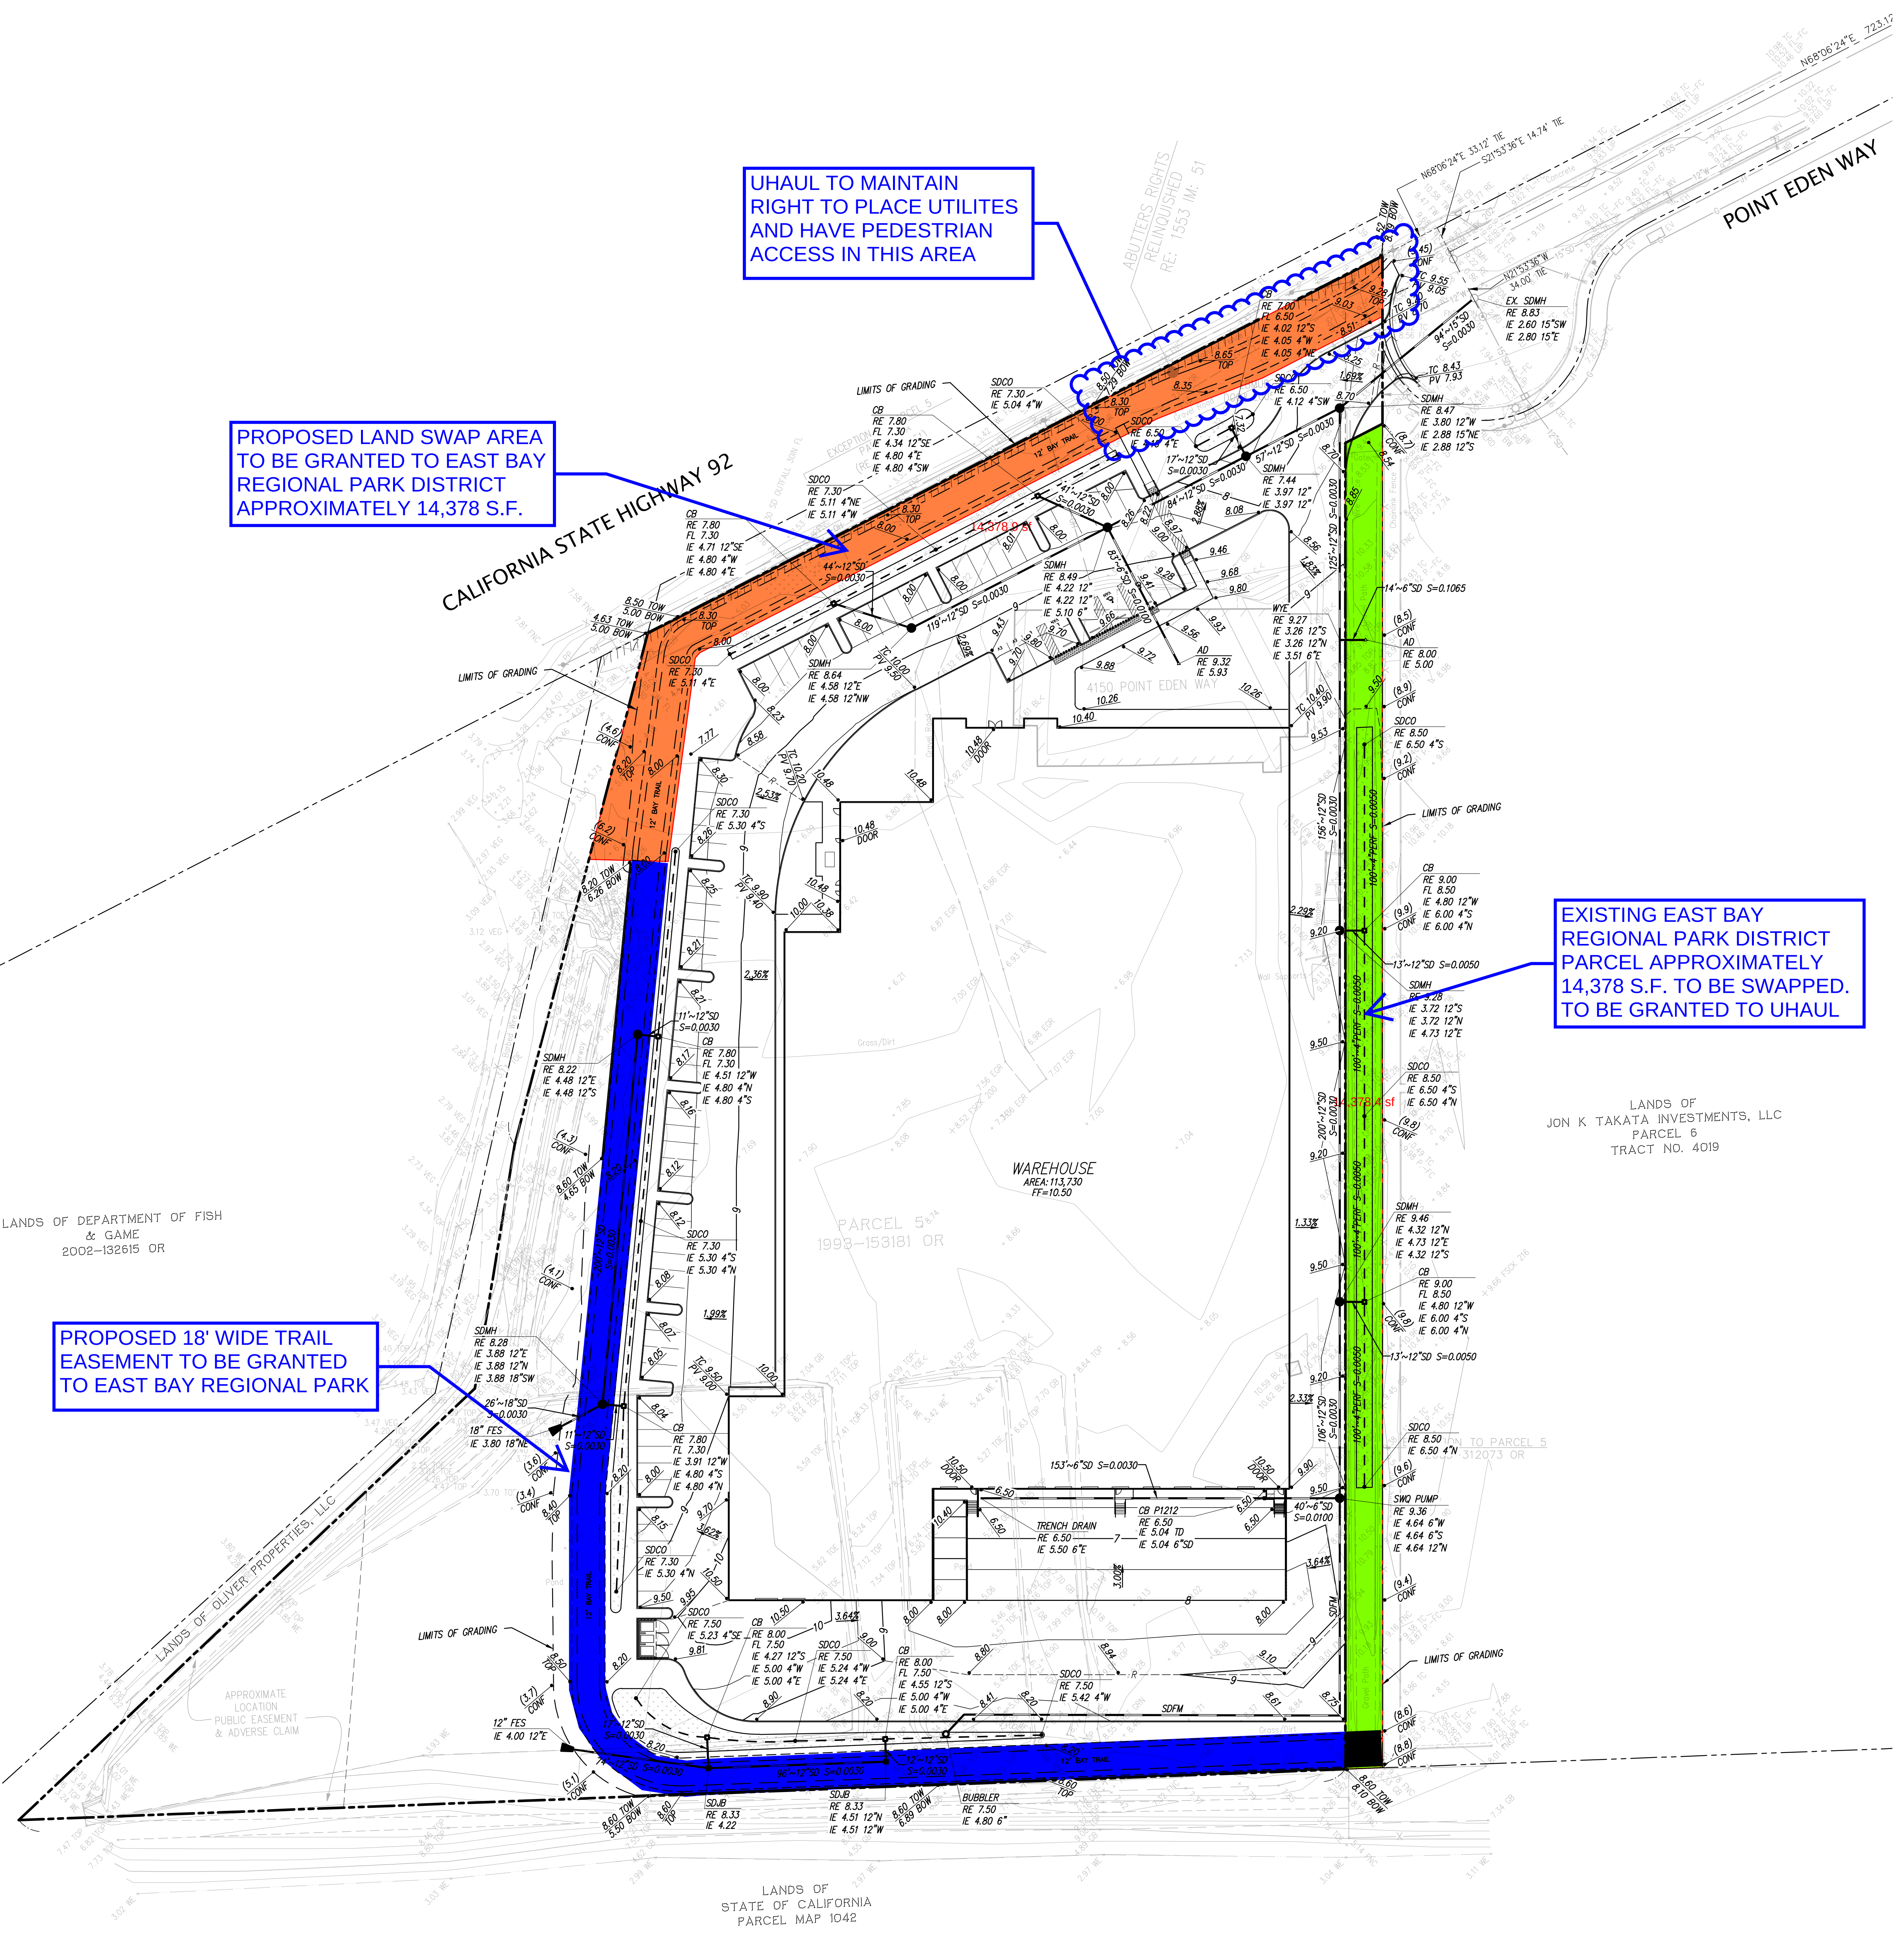

PROPOSED	EXISTING	LEGEND
		ASPHALT BERM
		BLOCK/RETAINING WALL
		BUILDING LINE
		EROSION CONTROL CURB
		CONCRETE CURB CUT
		CONCRETE CURB & GUTTER
		CONTOUR LINE
		EDGE OF PAVEMENT
		FENCE LINE
		LOT LINE
		MONUMENT/MANHOLE LINE
		PERFORATED STORM DRAIN PIPE
		PROPERTY LINE
		RAINWATER LEADER
		SIDE WALL
		STORM DRAIN-MANHOLE & CATCH BASIN
		THRU CURB DRAIN
		SPOT ELEVATION
		TRAFFIC SIGN
		TREE
		UTILITY BOX
		AREA DRAIN
		BACK OF WALK
		BUILDING
		BUILDING LINE
		CATCH BASIN
		CLEANOUT TO GRADE
		CONCRETE
		DOOR
		DOWN SPOUT
		DUCTILE IRON PIPE
		EASEMENT
		EDGE OF WALK
		FACE OF BERM
		FACE OF CURB
		FACE OF WALL
		FINISHED FLOOR
		FLOW LINE
		GRADE BREAK
		HIGH POINT
		INVERT ELEVATION
		LOW POINT
		LIGHT
		PAVEMENT
		RAINWATER LEADER
		RIDGE
		RIM ELEVATION
		ROOF DRAIN
		STORM DRAIN JUNCTION BOX
		STORM DRAIN MANHOLE
		SWALE
		TOP OF BERM
		TOP OF CURB
		TOP OF WALL
		TRANSFORMER
		TRASH ENCLOSURE
		BIO-FILTRATION SWALE

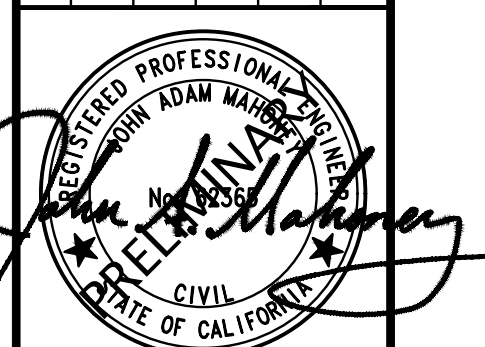

KIER+WRIGHT
2850 Collier Canyon Road
Livermore, CA 94551
Phone: (925) 245-9788
www.kierwright.com

PRELIMINARY GRADING AND DRAINAGE PLAN
OF
4150 POINTE EDEN WAY
FOR
U-HAUL, INC.

DATE	APRIL, 2020
SCALE	1" = 40'
DESIGNER	KS/SS
DRAWN BY	TB/JTQ
JOB NO.	A19640
SHEET	C2.0
OF	8 SHEETS