



**SHEET NOTES:**

1. SEE A400 FOR 'BASIS OF DESIGN' LUMINAIRE SCHEDULE.
2. CONFIRM LOCATIONS AND ALL SELECTIONS WITH OWNER PRIOR TO ORDER.

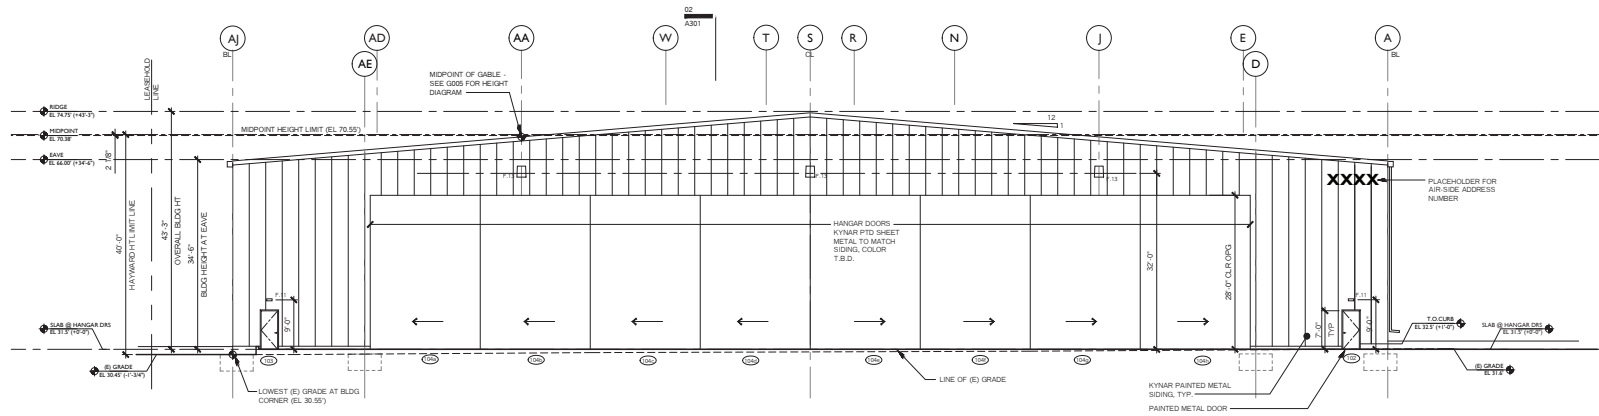

**01-SOUTH ELEVATION**

3/32" = 1'-0"

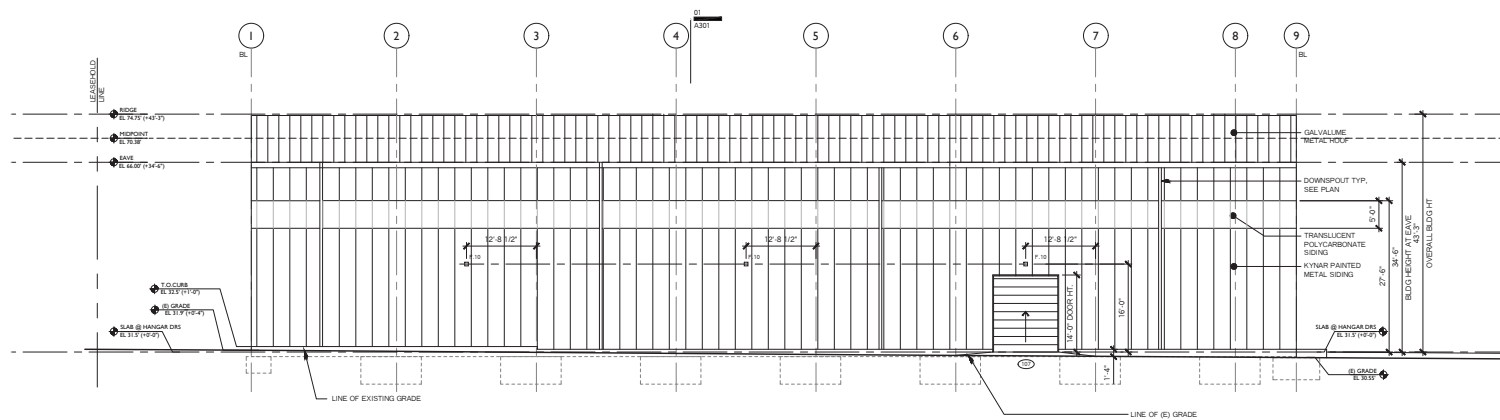


**02-WEST ELEVATION**

3/32" = 1'-0"





**Legend**  
■ APP Leasehold Hangar

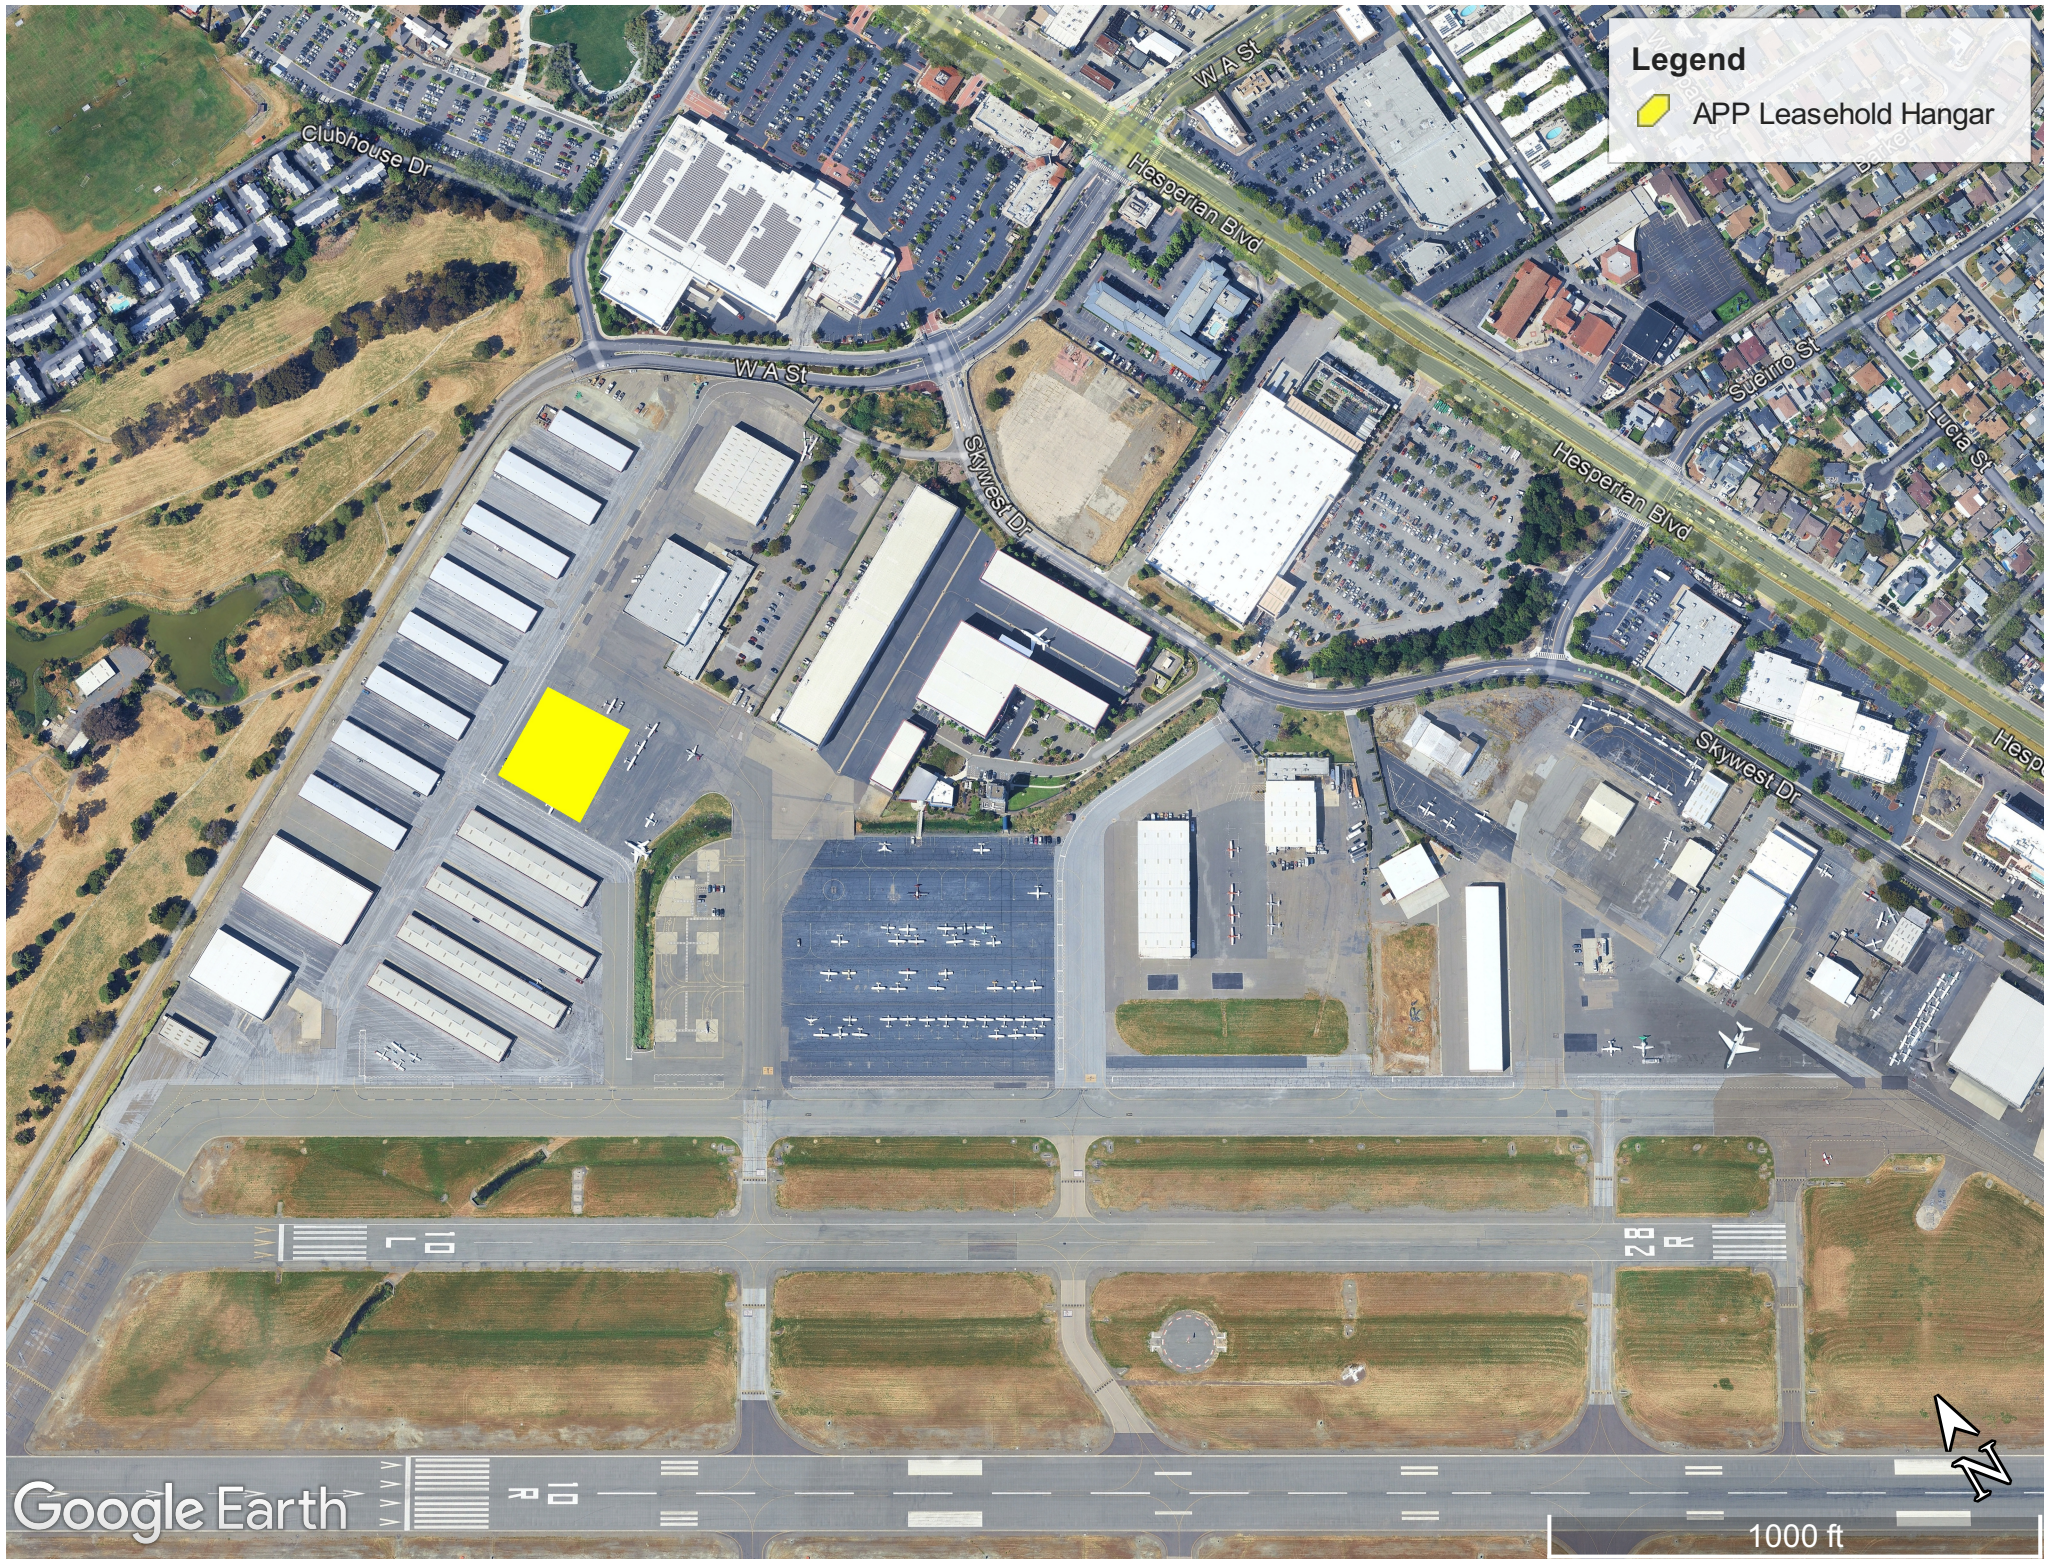

Google Earth

1000 ft